




PUBLIC NOTICE

May 16, 2000

STATE OF LOUISIANA
DEPARTMENT OF NATURAL RESOURCES
COASTAL MANAGEMENT DIVISION
P. O. BOX 44487
BATON ROUGE, LA 70804-4487
(225) 342-8917

CMD REVIEWER:
Jeff Thibodeaux

CUP NUMBER:
P990450(Modified)

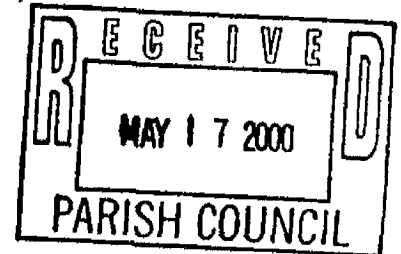

Interested parties are hereby notified that the Coastal Management Division of the Department of Natural Resources has received the following application for a Coastal Use Permit in accordance with the State and Local Coastal Resources Management Act of 1978, as amended, (Louisiana R.S. 49, Sections 214.21-214.41), and the rules and regulations of the Coastal Resources Program.

NAME: Sorrento Pipeline Company, LLC
c/o Morris P. Hebert
Attn: Michael Capello
P.O. Box 3106
Houma, LA 70361

LOCATION: St. Charles Parish, LA; approximately 1.5 miles north of Norco, LA; Sections 32, 42, 43, 21, 22, 25, and 26; T12S-R8E; POB: Lat. 30° 03' 30", Long. 90° 25' 23"; POE: Lat. 30° 00' 56", Long. 90° 24' 15"

DESCRIPTION: Proposed installation of approximately 17,689' of a 10" flowline. Approximately 17,000 cu. yds. of native material will be temporarily displaced and used as backfill. Approximately 11.5 acres of woodland habitat may be impacted by the proposed project.**

Modification: The modification consists of the installation of four 8" pipelines instead of one 10" pipeline. The impacts to forested wetlands has increased from 14.33 acres to 15.36 acres. The permittee has changed from Tejas to Sorrento Pipeline Company, LLC.

Habitat impacts are based on available in-house data and may not represent actual conditions. Field reconnaissance may be required to verify extent of impacts.

*The official date of the beginning of the public comment period for Coastal Use Permits and Water Quality Certification applications begins on the date of publication of the notice in the official state journal (The Advocate), in accordance with the Rules and Procedures for Coastal Use Permits, §723.C.5.c. The Coastal Management Division will inform interested parties of the exact date of publication on request.


2

The decision on whether to issue a permit will be based on an evaluation of the probable impacts of the proposed activity in accordance with the state policies outlines in R.S. 49:214.22. The decision will reflect the national concern for both protection and utilization of important resources. The decision must be consistent with the State program and approved local programs for affected parishes and must represent an appropriate balancing of social, environmental and economic factors. All factors which may be relevant to the proposal will be considered; among these are flood and storm hazards, water quality, water supply, feasible alternative sites, drainage patterns, historical sites, economics, public and private benefits, coastal water-dependency, impacts on natural features, compatibility with the natural and cultural setting and the extent of long benefits or adverse impacts.

Certification that the proposed activity will not violate applicable water and air quality laws, standards and regulations will be required before a permit is issued.

Any person may request, in writing, within the comment period specified in this notice, that a public hearing be held to consider this application. Requests for public hearing shall state, with particularity, the reasons for holding a public hearing.

Plans for the proposed work may be inspected at the Office of Coastal Management Division, 625 North 4th Street, 10th Floor, Baton Rouge, Louisiana, (504)342-7591. Comments must be mailed with 25 days of the date of official journal publication (Baton Rouge Advocate) of this notice to Coastal Management Division, P.O. Box 44487, Baton Rouge, LA 70804-4487.

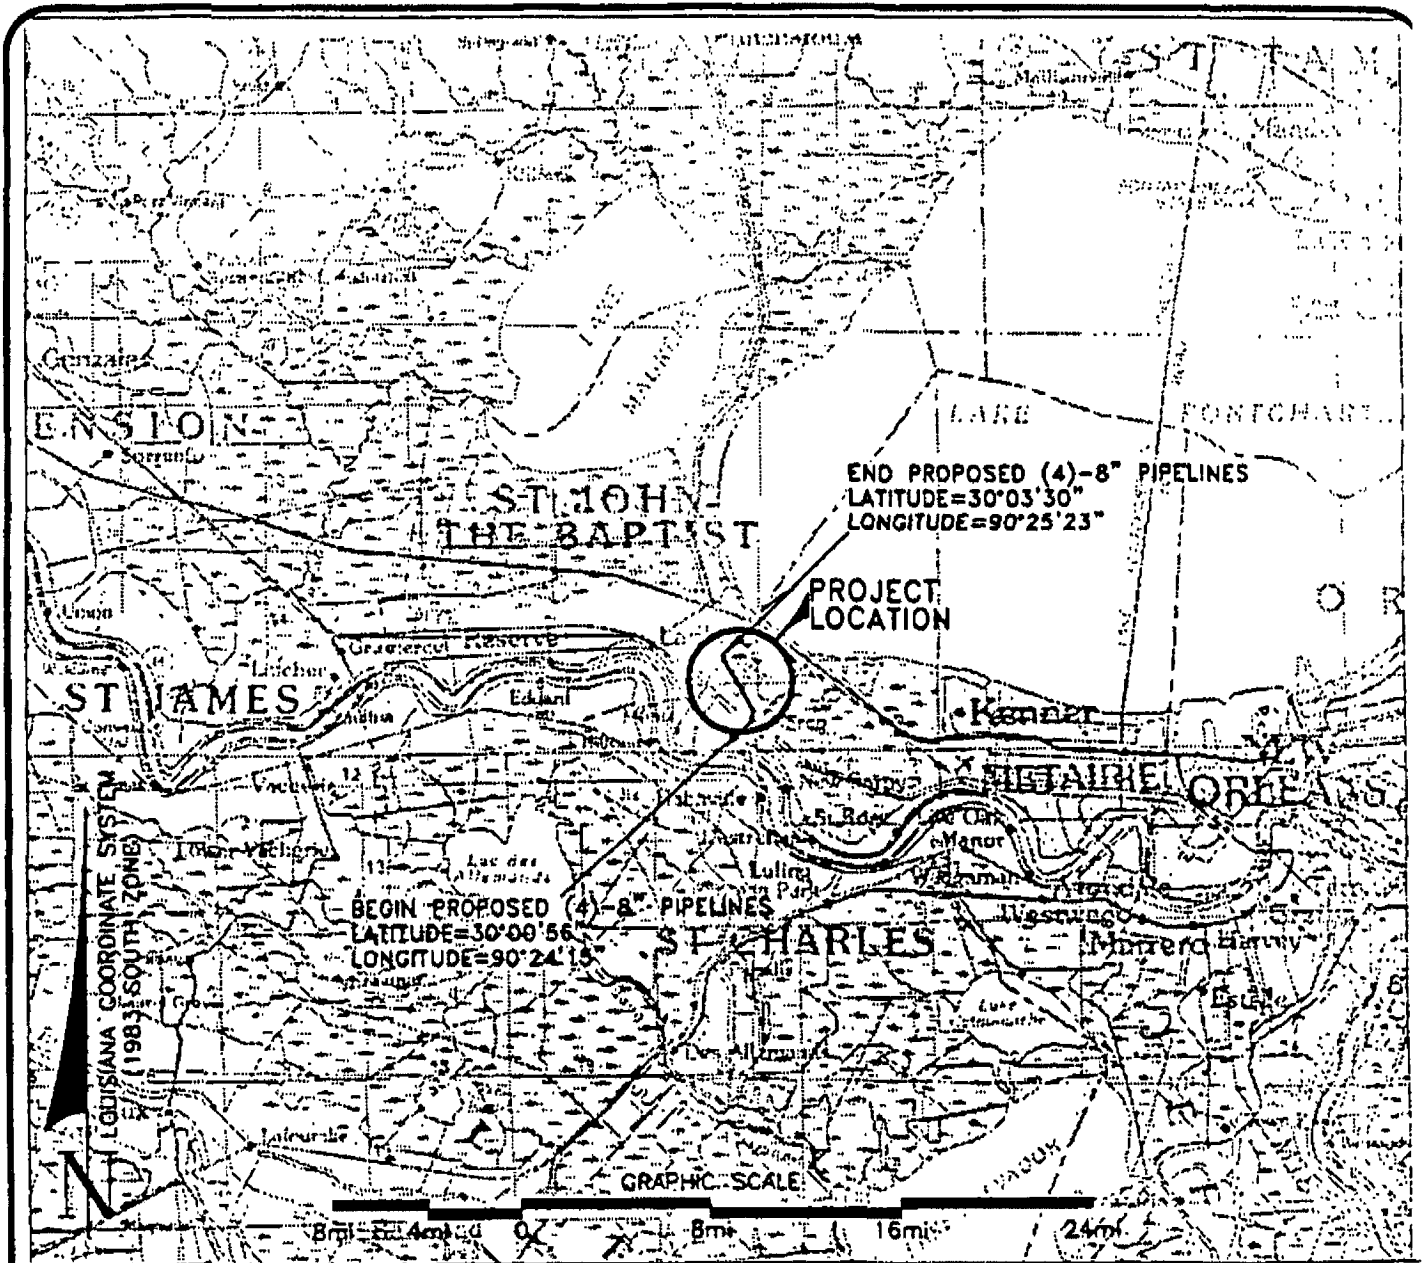


NO.	DATE	REVISION

SORRENTO PIPELINE COMPANY, LLC

PROPOSED (4)-8" PIPELINES
 FROM ENTERPRISE NORCO REFRACTIONATOR TO
 TRI-STATES VALVE LOCATED IN
 SECTIONS 32, 42 & 43, T11S-R8E AND SECTIONS 21, 22, 25 & 26, T12S-R8E,
 ST. CHARLES PARISH, LOUISIANA


Morris P. Hebert, Inc.
 PROFESSIONAL LAND & HYDROGRAPHIC SURVEYORS
 P.O. BOX 3108 • HOUMA, LOUISIANA 70381-3108 • (504) 879-2731

DRAWN BY: GWN	SHEET: 1
CHECKED BY: JMH	SCALE: 1"=8 miles
APPROVED BY: DEC	DATE: 2-24-00
MPH CAD FILE: 6014COE0001A0	(4)

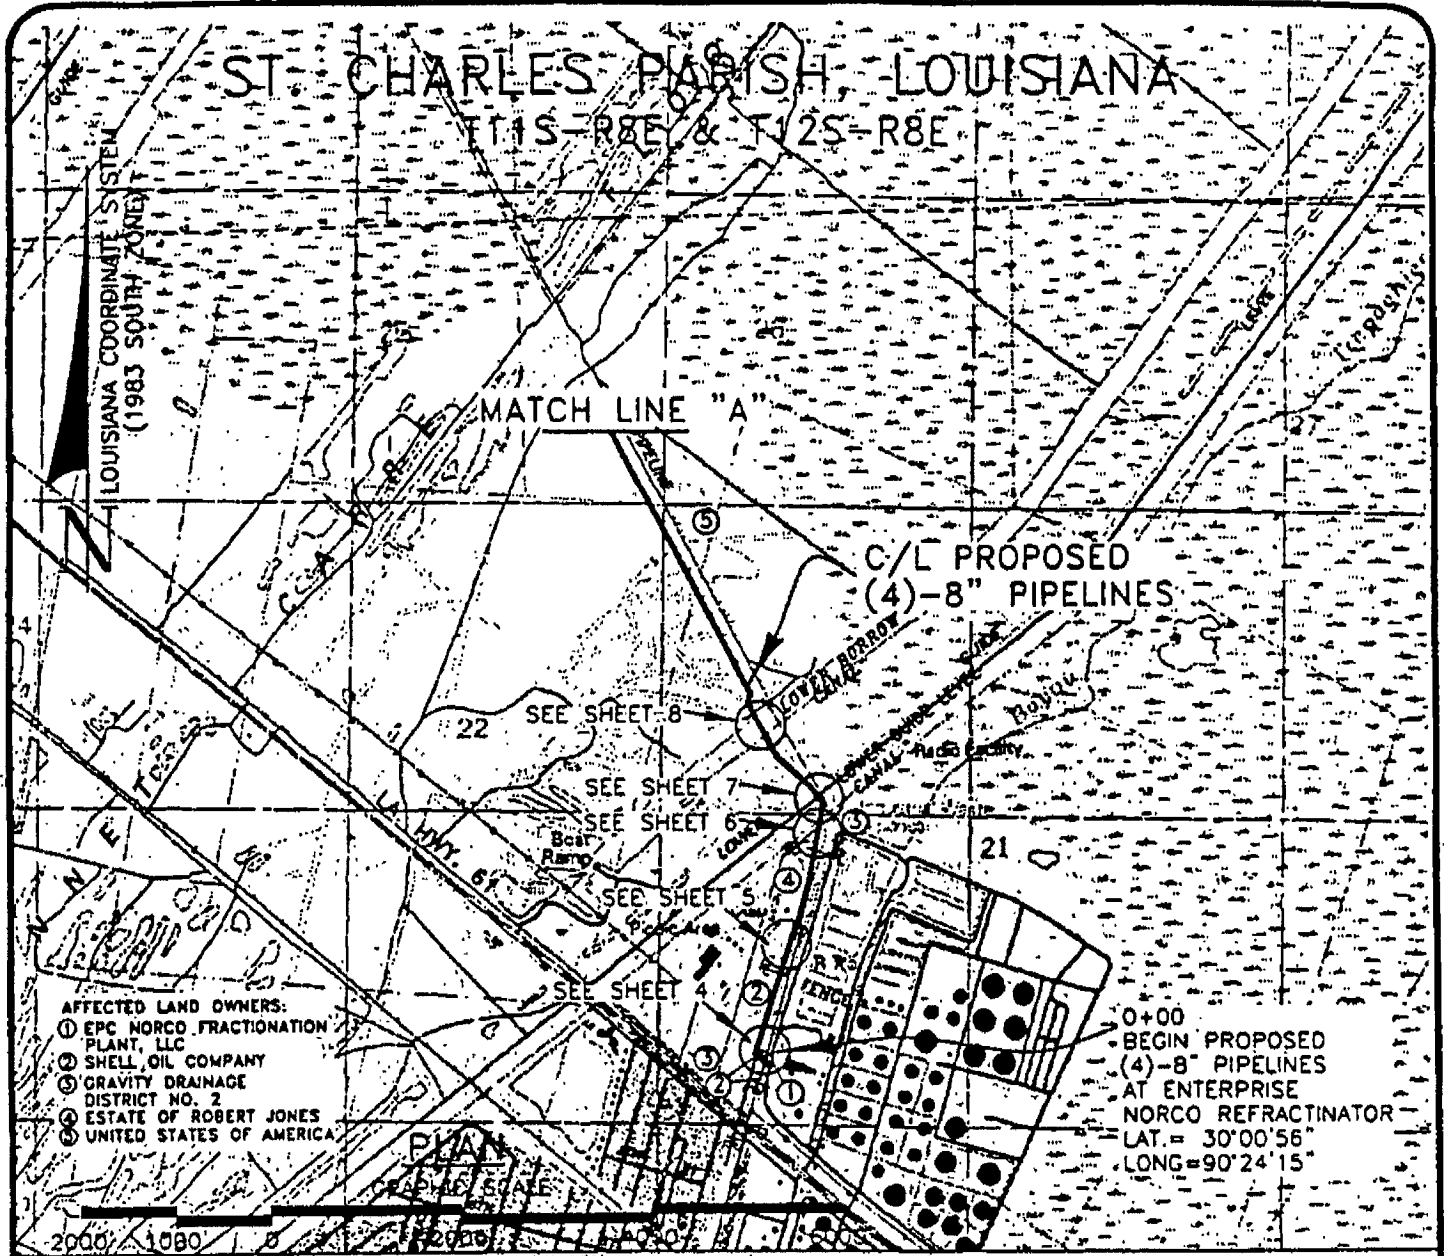


NO.	DATE	REVISION

SORRENTO PIPELINE COMPANY, LLC


PROPOSED (4)-8" PIPELINES
 FROM ENTERPRISE NORCO REFRACTORATOR TO
 TRI-STATES VALVE LOCATED IN
 SECTIONS 32, 42 & 43, T11S-R8E AND SECTIONS 21, 22, 25 & 26, T12S-R8E,
 ST. CHARLES PARISH, LOUISIANA

MPH
Morris P. Hebert, Inc.
 PROFESSIONAL LAND & HYDROGRAPHIC SURVEYORS
 P.O. BOX 3106 • NOUIVA, LOUISIANA 70361-3106 • (504) 879-2751

DRAWN BY: GWN	SHEET: 2
CHECKED BY: JMH	SCALE: SHOWN
APPROVED BY: DEC	DATE: 2-24-00
MPH CAD FILE: 6014COE0002A0	

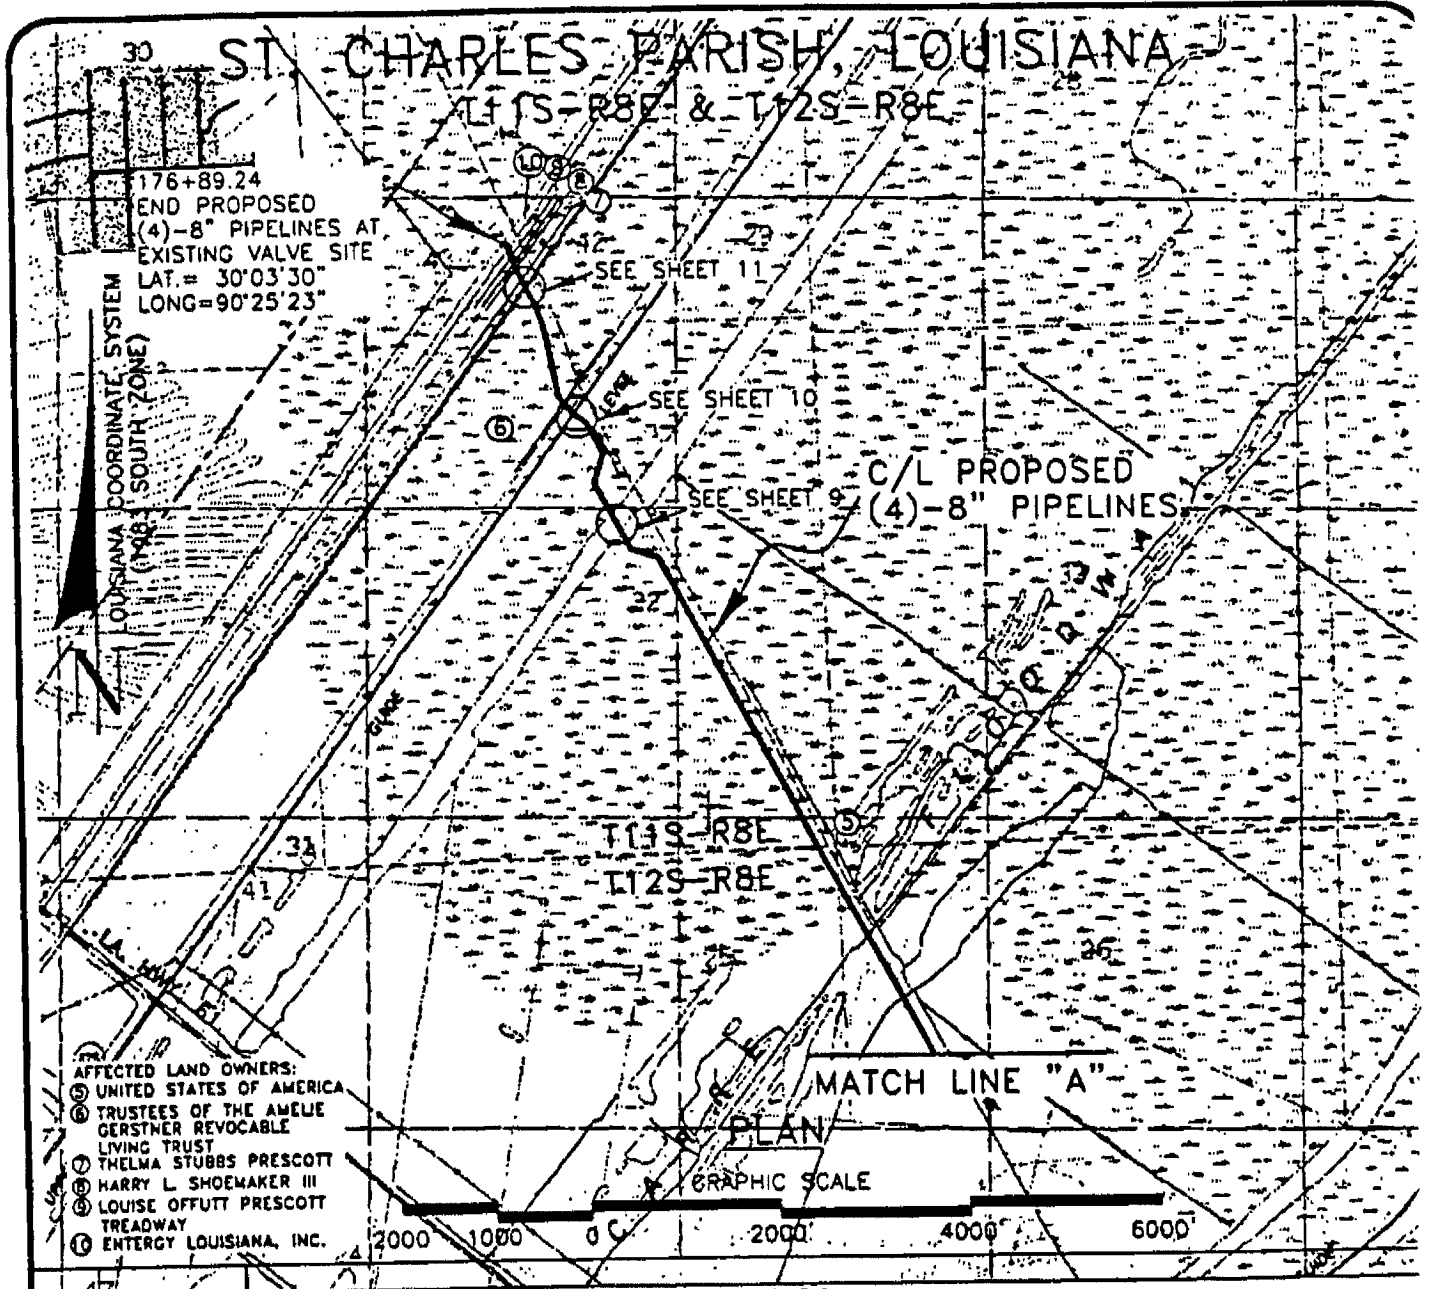

 - AFFECTED LAND OWNERS:
- ⑤ UNITED STATES OF AMERICA
 - ⑥ TRUSTEES OF THE AMELIE GERSTNER REVOCABLE LIVING TRUST
 - ⑦ THELMA STUBBS PRESCOTT
 - ⑧ HARRY L. SHOEMAKER III
 - ⑨ LOUISE OFFUTT PRESCOTT TREADWAY
 - ⑩ ENTERGY LOUISIANA, INC.



NO.	DATE	REVISION
-----	------	----------

SORRENTO PIPELINE COMPANY, LLC

PROPOSED (4)-8" PIPELINES
 FROM ENTERPRISE NORCO REFRACTIONATOR TO
 TRI-STATES VALVE LOCATED IN
 SECTIONS 32, 42 & 43, T11S-R8E AND SECTIONS 21, 22, 25 & 26, T12S-R8E. (c)

ST. CHARLES PARISH, LOUISIANA




Morris P. Hebert, Inc.
 PROFESSIONAL LAND & HYDROGRAPHIC SURVEYORS
 P.O. BOX 3108 • HOUMA, LOUISIANA 70361-3108 • (504) 879-2731

DRAWN BY: GWN	SHEET: 3
CHECKED BY: JMH	SCALE: SHOWN
APPROVED BY: DEC	DATE: 2-24-00
MPH CAD FILE: 6014COE0003A0	

ST. CHARLES PARISH, LOUISIANA


SECTION 21, T12S-R8E

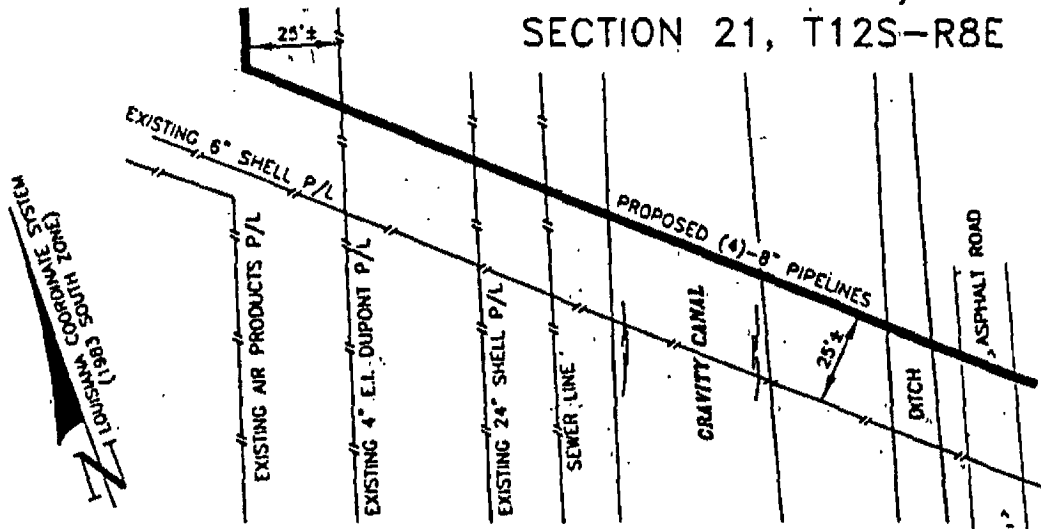


SEE SHEET 13 FOR
EXTRA WORKSPACE AND
RIGHT-OF-WAY INFORMATION

PLAN

 GRAPHIC SCALE



SEE SHEET 19 FOR
BANK STABILIZATION
DETAIL

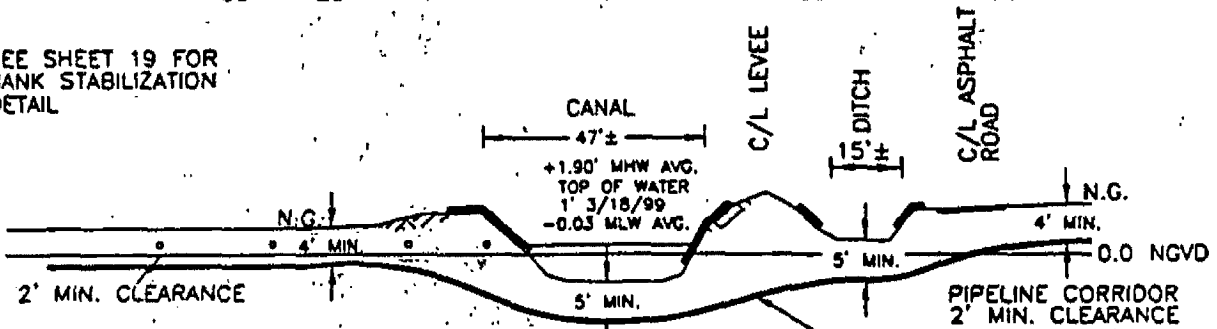

BASED ON THE LAKE
PONTCHARTRAIN AT
FRENIER, LA. GAUGE
NO. 8555006, 8AM READING

PROFILE

LOOKING NORTHEASTERLY
VERTICAL SCALE
1" = 20'

PROPOSED 8" PIPELINES

NOTE: PIPELINE TO BE INSTALLED
BY DIRECTIONAL DRILL OR
OPEN CUT METHOD.

NO.	DATE	REVISION

SORRENTO PIPELINE COMPANY, LLC

PROPOSED (4)-8" PIPELINES
FROM ENTERPRISE NORCO REFRACATIONATOR TO
TRI-STATES VALVE LOCATED IN
SECTIONS 32, 42 & 43, T11S-R8E AND SECTIONS 21, 22, 25 & 26, T12S-R8E,
ST. CHARLES PARISH, LOUISIANA



Morris P. Hebert, Inc.


PROFESSIONAL LAND & HYDROGRAPHIC SURVEYORS

P.O. BOX 3106 • MOULANA, LOUISIANA 70381-3106 • (504) 879-2731

DRAWN BY: GWN	SHEET: 4
CHECKED BY: JMH	SCALE: SHOWN
APPROVED BY: DEC	DATE: 2-24-00
MPH CAD FILE: 6014COE000440	

ST. CHARLES PARISH, LOUISIANA

SECTION 21, T12S-R8E

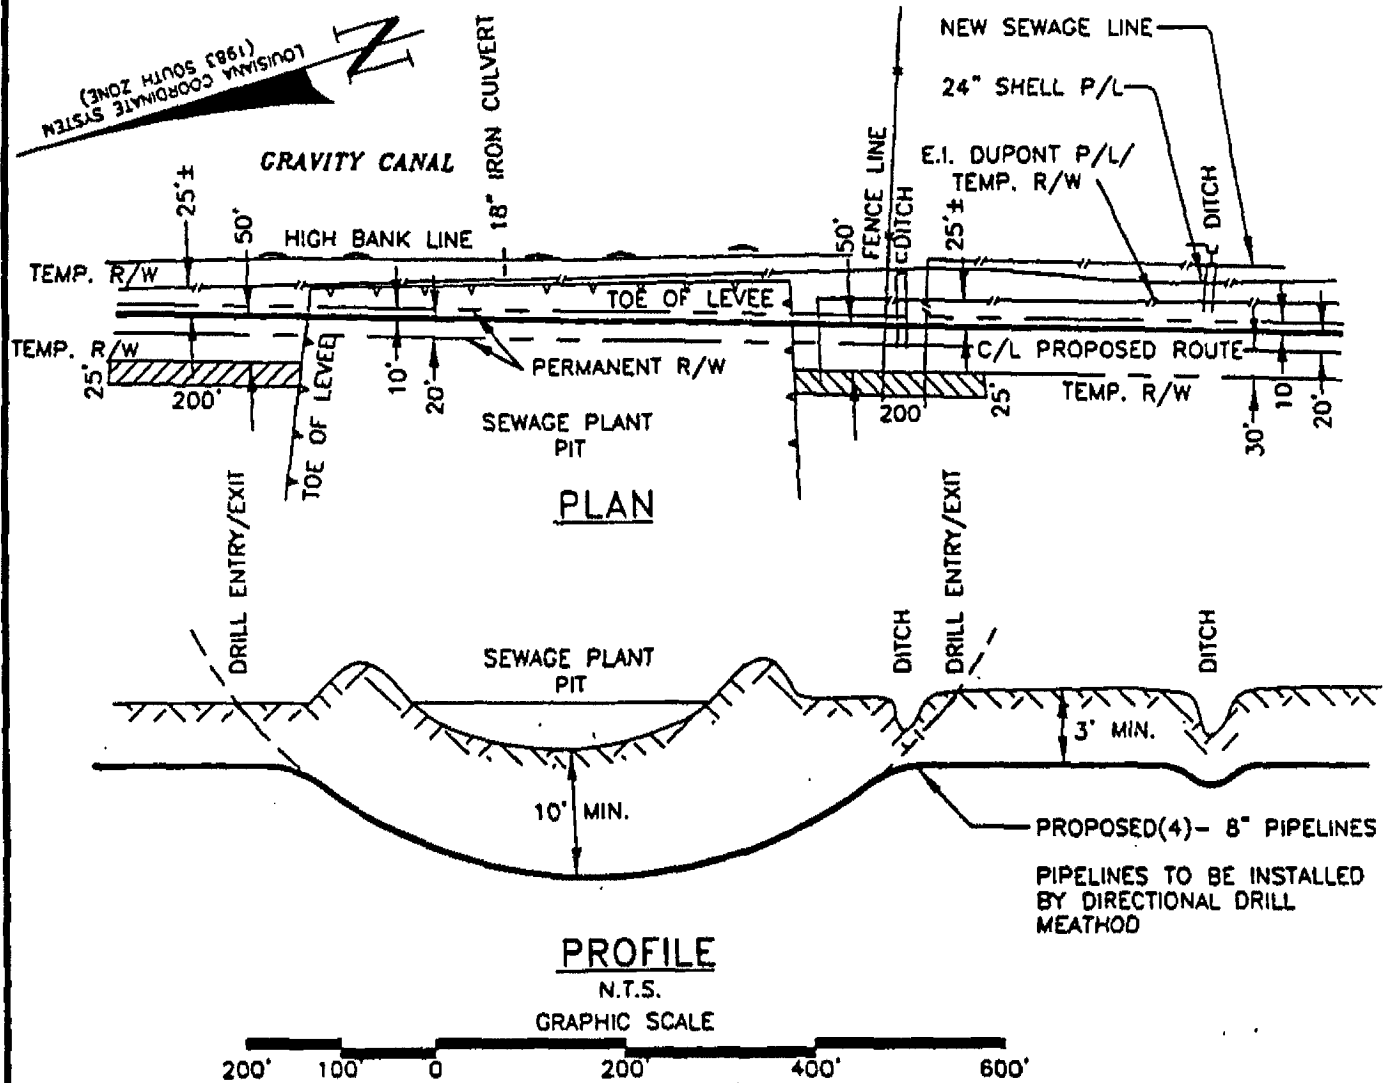

NO.	DATE	REVISION

SORRENTO PIPELINE COMPANY, LLC

PROPOSED (4)-8" PIPELINES
 FROM ENTERPRISE NORCO REFRACTIONATOR TO
 TRI-STATES VALVE LOCATED IN
 SECTIONS 32, 42 & 43, T11S-R8E AND SECTIONS 21, 22, 25 & 26, T12S-R8E,
 ST. CHARLES PARISH, LOUISIANA



Morris P. Hebert, Inc.
 PROFESSIONAL LAND & HYDROGRAPHIC SURVEYORS
 P.O. BOX 3106 • NOUMEA, LOUISIANA 70381-3106 • (504) 879-2731



DRAWN BY: GWN	SHEET: 5
CHECKED BY: JMH	SCALE: SHOWN
APPROVED BY: DEC	DATE: 2-24-00
MPH CAD FILE: 6014COE0005AD	

8

ST. CHARLES PARISH, LOUISIANA

SECTION 21, T12S-R8E GRAVITY CANAL

LOUISIANA COORDINATE SYSTEM
(1983 SOUTH ZONE)

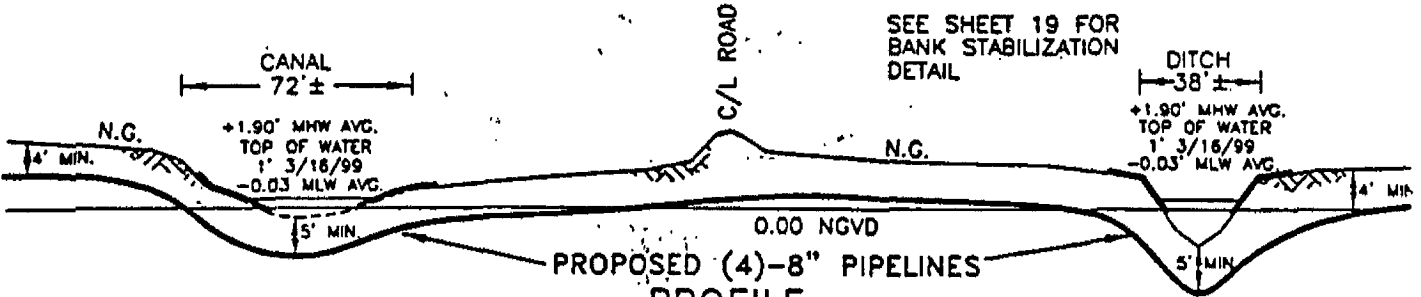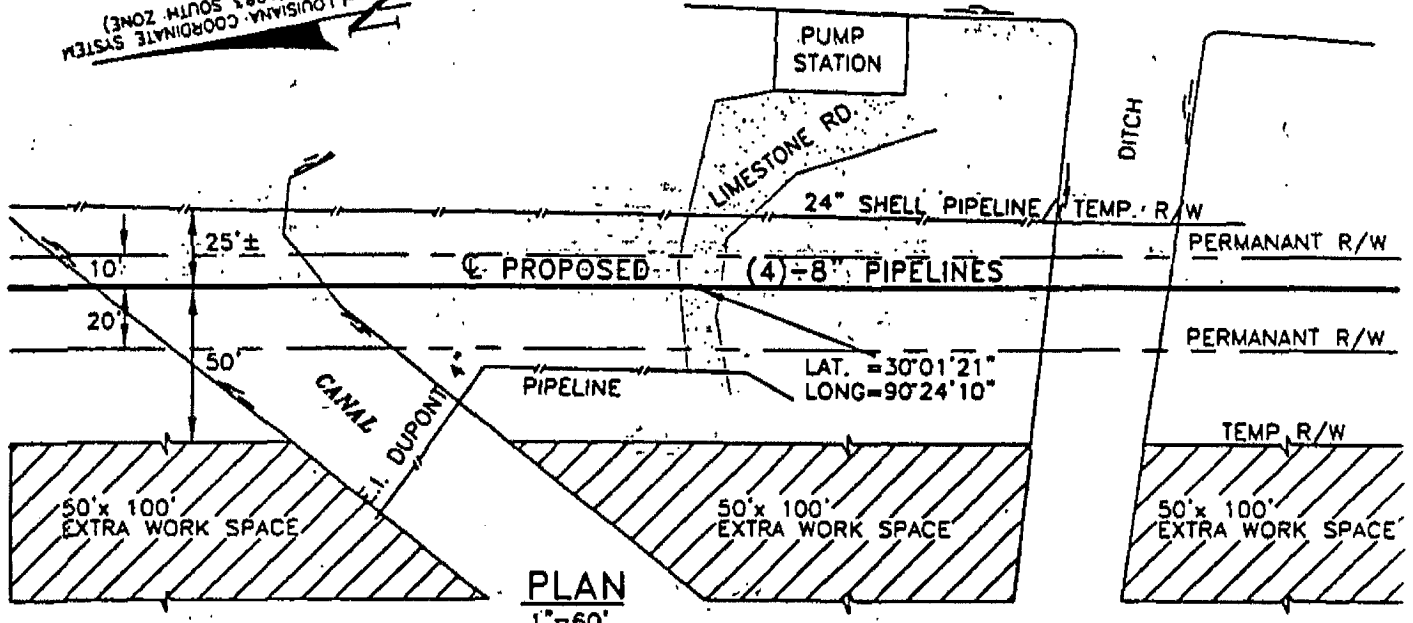

BASED ON THE LAKE PONTCHARTRAIN AT FRENIER, LA. GAUGE NO. 8555006, BAM READING

NOTE: PIPELINE TO BE INSTALLED BY DIRECTIONAL DRILL OR OPEN CUT METHOD.

NO.	DATE	REVISION

SORRENTO PIPELINE COMPANY, LLC


PROPOSED (4)-8" PIPELINES FROM ENTERPRISE NORCO REFRACTIONATOR TO TRI-STATES VALVE LOCATED IN SECTIONS 32, 42 & 43, T11S-R8E AND SECTIONS 21, 22, 25 & 26, T12S-R8E, ST. CHARLES PARISH, LOUISIANA

MPH
Morris P. Hebert, Inc.
PROFESSIONAL LAND & HYDROGRAPHIC SURVEYORS
P.O. BOX 3108 • MOUMA, LOUISIANA 70381-3108 • (504) 879-2731

DRAWN BY: GWN	SHEET: 6
CHECKED BY: JMH	SCALE: SHOWN
APPROVED BY: DEC	DATE: 2-24-00
MPH CAD FILE: 6014COEQ006AD	


ST. CHARLES PARISH, LOUISIANA

SECTION 21, T12S-R8E

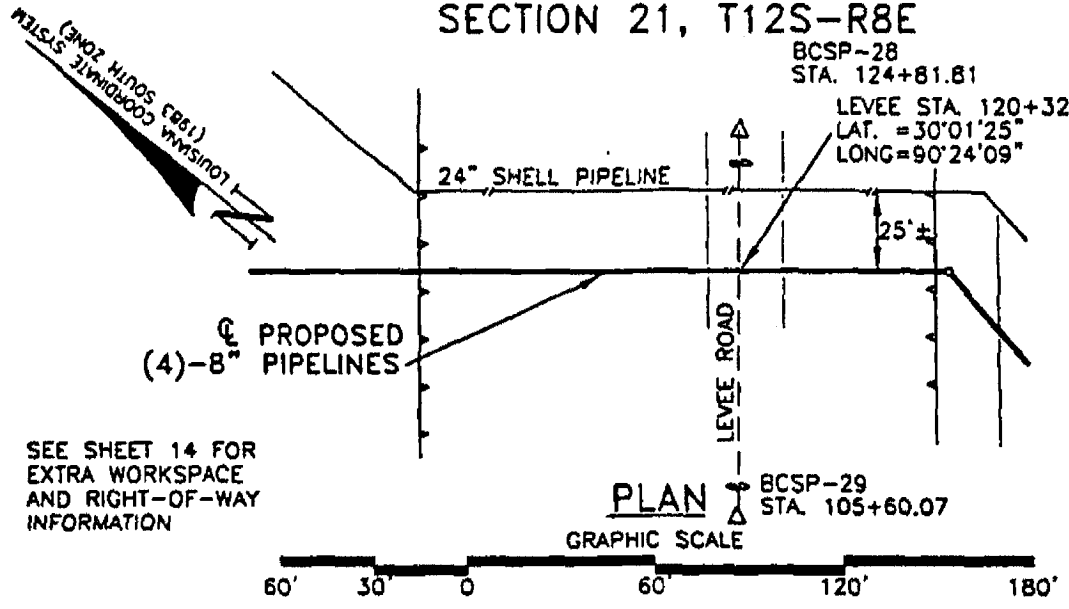

SEE SHEET 14 FOR
EXTRA WORKSPACE
AND RIGHT-OF-WAY
INFORMATION


LOWER GUIDE LEVEE

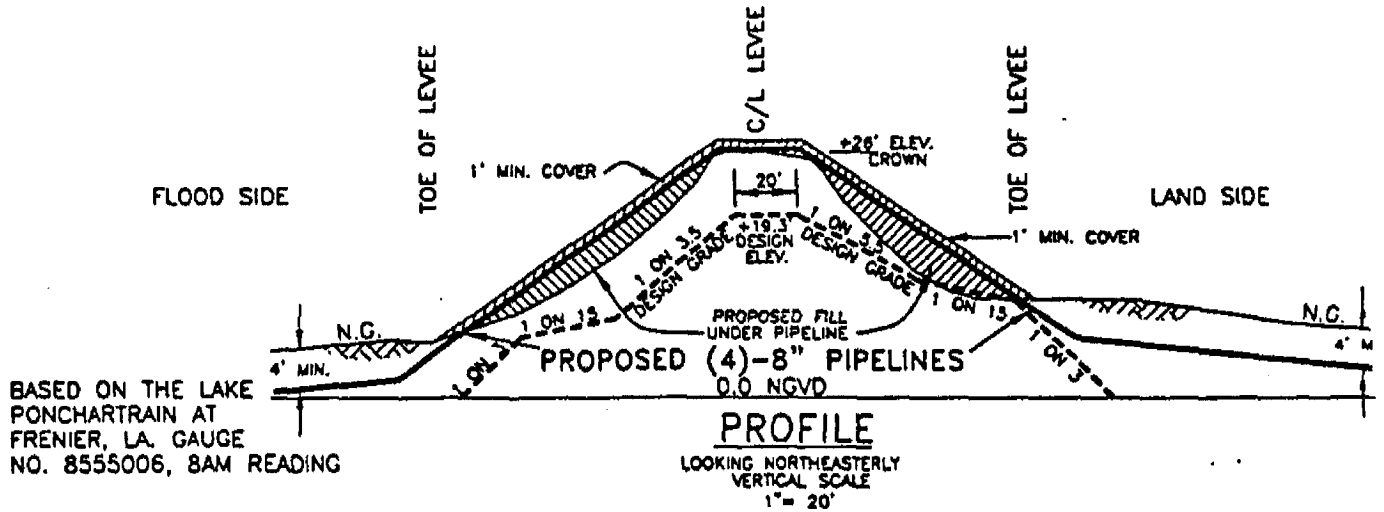

NO.	DATE	REVISION

SORRENTO PIPELINE COMPANY, LLC

 PROPOSED (4)-8" PIPELINES
FROM ENTERPRISE NORCO REFRACTIONATOR TO
TRI-STATES VALVE LOCATED IN
SECTIONS 32, 42 & 43, T11S-R8E AND SECTIONS 21, 22, 25 & 26, T12S-R8E,
ST. CHARLES PARISH, LOUISIANA



Morris P. Hebert, Inc.
PROFESSIONAL LAND & HYDROGRAPHIC SURVEYORS
P.O. BOX 3108 • MOUMA, LOUISIANA 70361-3108 • (504) 879-2731


DRAWN BY: GWN	SHEET: 7
CHECKED BY: JMH	SCALE: SHOWN
APPROVED BY: DEC	DATE: 2-24-00
MPH CAD FILE: 6014COE0007AD	

10


ST. CHARLES PARISH, LOUISIANA

SECTION 21, T12S-R8E

LOUISIANA COORDINATE SYSTEM (1983 SOUTH ZONE)

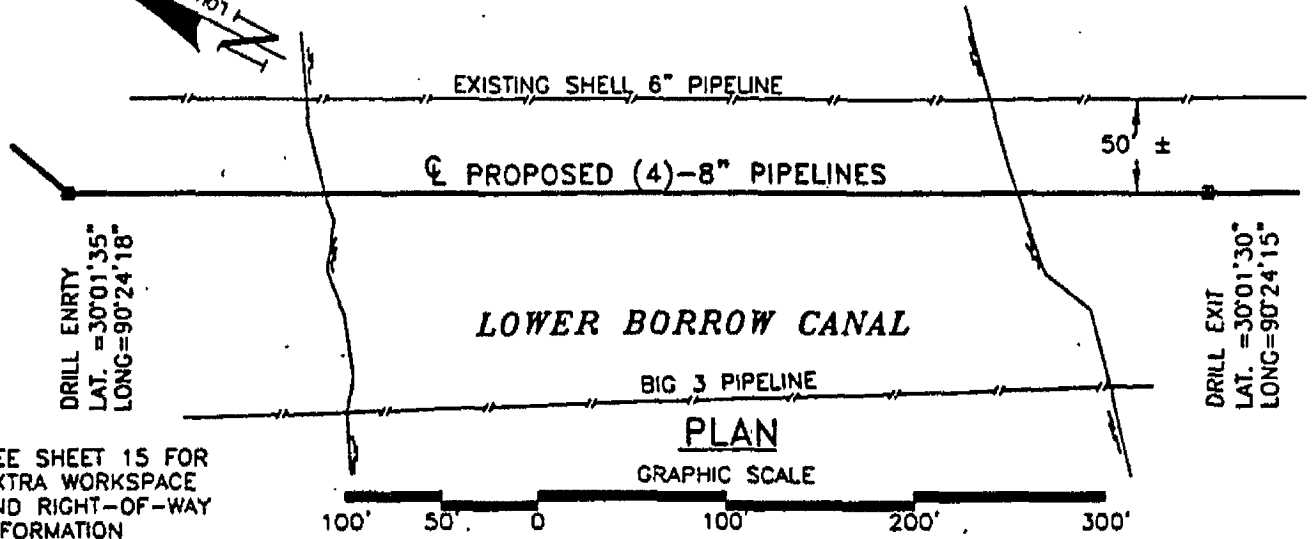

SEE SHEET 15 FOR
EXTRA WORKSPACE
AND RIGHT-OF-WAY
INFORMATION

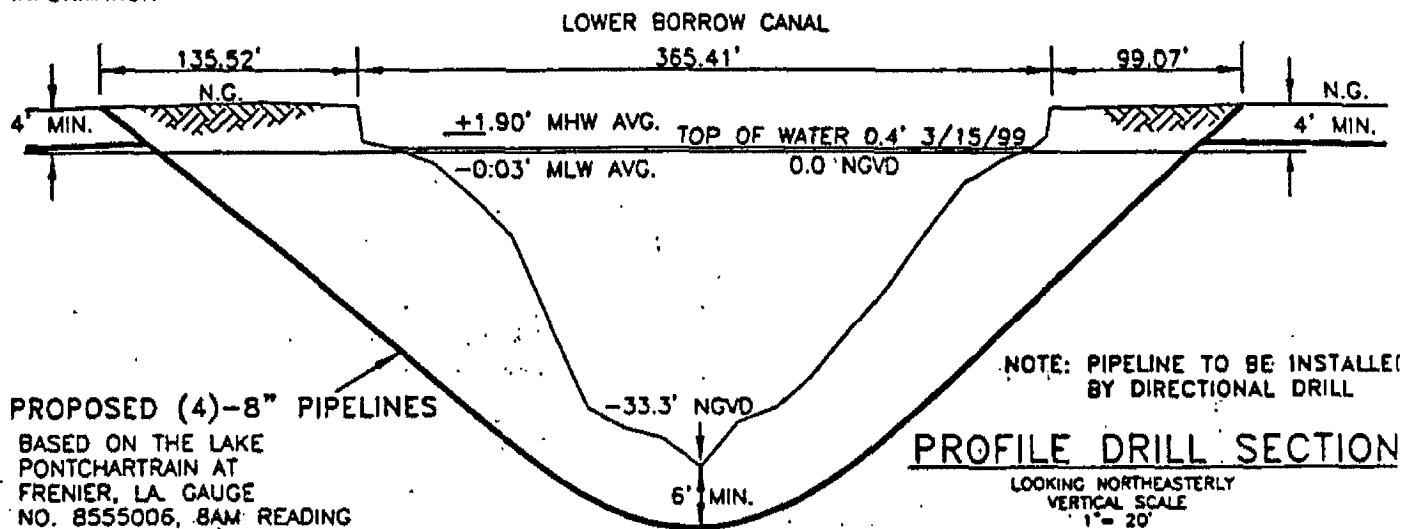

PROPOSED (4)-8" PIPELINES
BASED ON THE LAKE
PONTCHARTRAIN AT
FRENIER, LA. GAUGE
NO. 8555006, 8AM READING

NOTE: PIPELINE TO BE INSTALLED
BY DIRECTIONAL DRILL

PROFILE DRILL SECTION
LOOKING NORTHEASTERLY
VERTICAL SCALE
1" = 20'

NO.	DATE	REVISION

SORRENTO PIPELINE COMPANY, LLC

PROPOSED (4)-8" PIPELINES
FROM ENTERPRISE NORCO REFRACTIONATOR TO
TRI-STATES VALVE LOCATED IN
SECTIONS 32, 42 & 43, T11S-R8E AND SECTIONS 21, 22, 25 & 26, T12S-R8E,
ST. CHARLES PARISH, LOUISIANA


Morris P. Hebert, Inc.
PROFESSIONAL LAND & HYDROGRAPHIC SURVEYORS
P.O. BOX 3106 • HOUMA, LOUISIANA 70361-3106 • (504) 879-2731

DRAWN BY: GWN	SHEET: 8
CHECKED BY: JMH	SCALE: SHOWN
APPROVED BY: DEC	DATE: 2-24-00
MPH CAD FILE: 6014COE0008AD	



ST. CHARLES PARISH, LOUISIANA

SECTION 32, T11S-R8E

(3002 41005 0861)
LOUISIANA COORDINATE SYSTEM
SOUTH ZONE

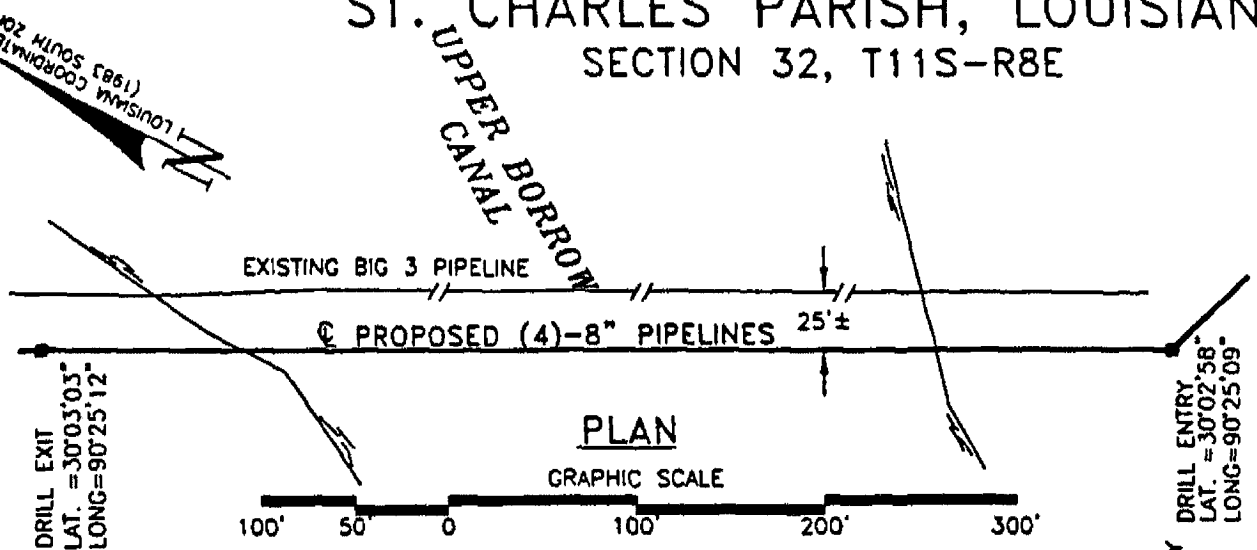

DRILL EXIT
SEE SHEET 16 FOR
EXTRA WORKSPACE
AND RIGHT-OF-WAY
INFORMATION

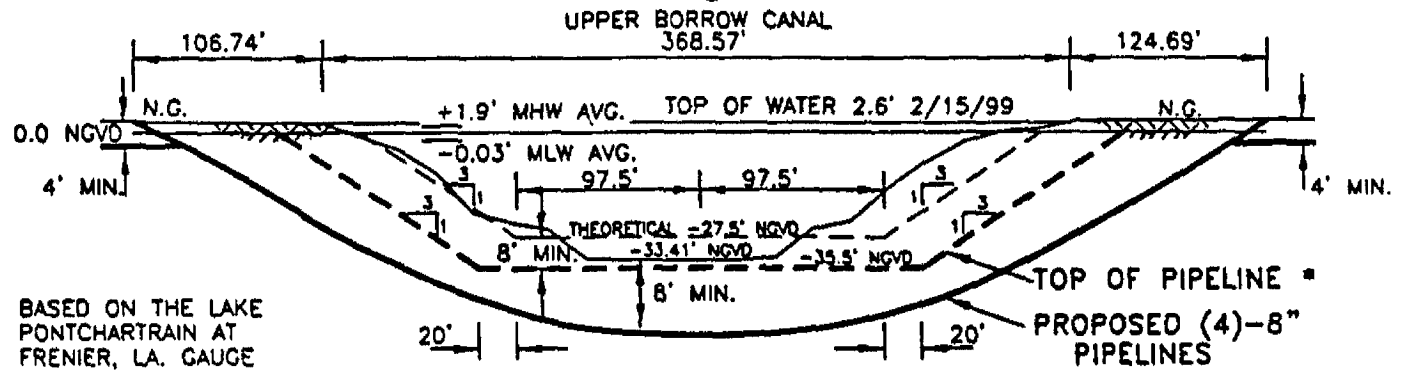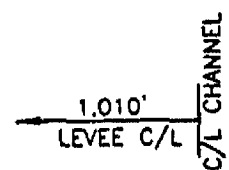

BASED ON THE LAKE
PONTCHARTRAIN AT
FRÉNIER, LA. GAUGE
NO. 8555006, 8AM READING

PROFILE DRILL SECTION

*NOTE:
MINIMUM DEPTH PIPELINE DESIGN
CROSSING PROVIDED BY COE.

LOOKING NORTHEASTERLY
VERTICAL SCALE
1" = 50'

NOTE: PIPELINE TO BE INSTALLED
BY DIRECTIONAL DRILL

NO.	DATE	REVISION

SORRENTO PIPELINE COMPANY, LLC

PROPOSED (4)-8" PIPELINES
FROM ENTERPRISE NORCO REFRACTIONATOR TO
TRI-STATES VALVE LOCATED IN
SECTIONS 32, 42 & 43, T11S-R8E AND SECTIONS 21, 22, 25 & 26, T12S-R8E,
ST. CHARLES PARISH, LOUISIANA


MPH
Morris P. Hebert, Inc.
PROFESSIONAL LAND & HYDROGRAPHIC SURVEYORS
P.O. BOX 3108 • MOULANA, LOUISIANA 70361-3108 • (504) 879-2731

DRAWN BY: GWN	SHEET: 9
CHECKED BY: JMH	SCALE: SHOWN
APPROVED BY: DEC	DATE: 2-24-00
MPH CAD FILE: 6014COE0009A0	

12


ST. CHARLES PARISH, LOUISIANA

SECTION 32 & 42, T11S-R8E

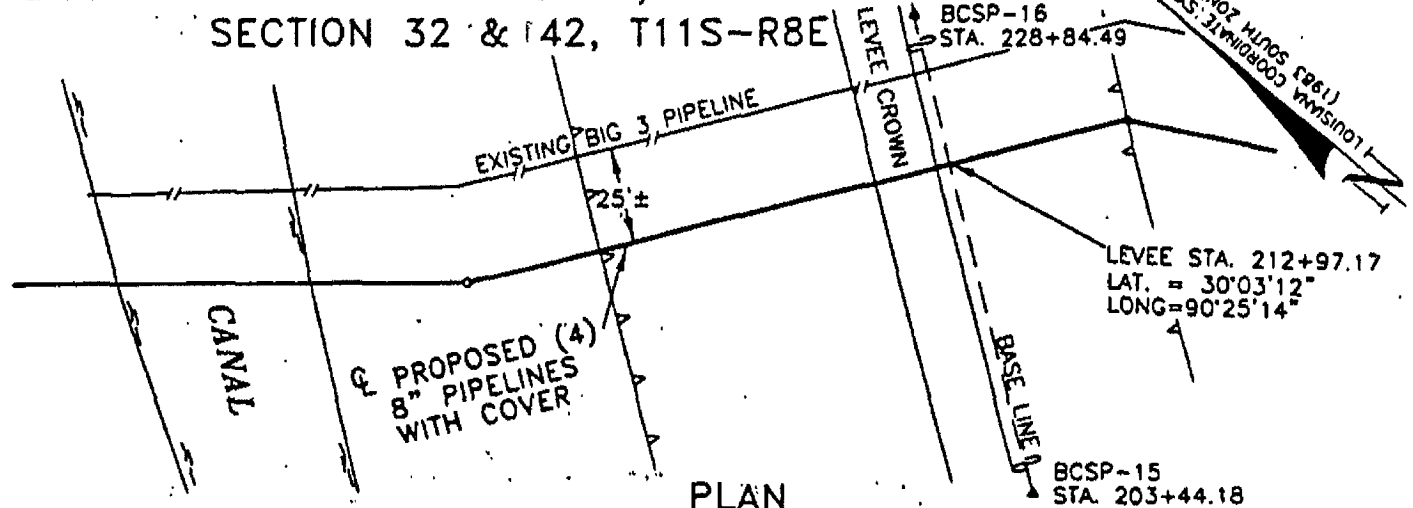


PLAN

 GRAPHIC SCALE



SEE SHEET 17 FOR
EXTRA WORKSPACE
AND RIGHT-OF-WAY
INFORMATION

UPPER GUIDE LEVEE

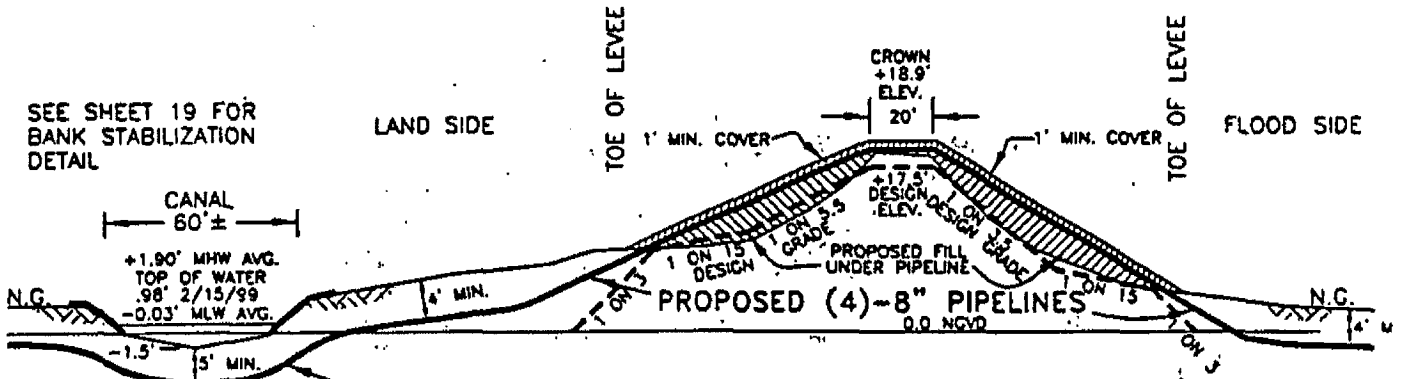

PROFILE

LOOKING NORTHEASTERLY
VERTICAL SCALE
1" = 20'

SEE SHEET 19 FOR
BANK STABILIZATION
DETAIL

BASED ON THE LAKE
PONTCHARTRAIN AT
FRENIER, LA. GAUGE
NO. 8555006, 8AM READING

NOTE: PIPELINES TO BE INSTALLED
BY DIRECTIONAL DRILL OR
OPEN CUT METHOD.

NO.	DATE	REVISION

SORRENTO PIPELINE COMPANY, LLC

PROPOSED (4)-8" PIPELINES
FROM ENTERPRISE NORCO REFRACATIONATOR TO
TRI-STATES VALVE LOCATED IN
SECTIONS 32, 42 & 43, T11S-R8E AND SECTIONS 21, 22, 25 & 26, T12S-R8E,
ST. CHARLES PARISH, LOUISIANA

13



Morris P. Hebert, Inc.

PROFESSIONAL LAND & HYDROGRAPHIC SURVEYORS


P.O. BOX 3106 • MONROE, LOUISIANA 70361-3106 • (504) 879-2731

DRAWN BY: GWN	SHEET: 10
CHECKED BY: JMH	SCALE: SHOWN
APPROVED BY: DEC	DATE: 2-24-00
MPH CAD FILE: 6014COE0010A0	


ST. CHARLES PARISH, LOUISIANA

SECTION 42, T11S-R8E

LOUISIANA COORDINATE SYSTEM (GNDZ H/LDS (9861) 1983 SOUTH ZONE)

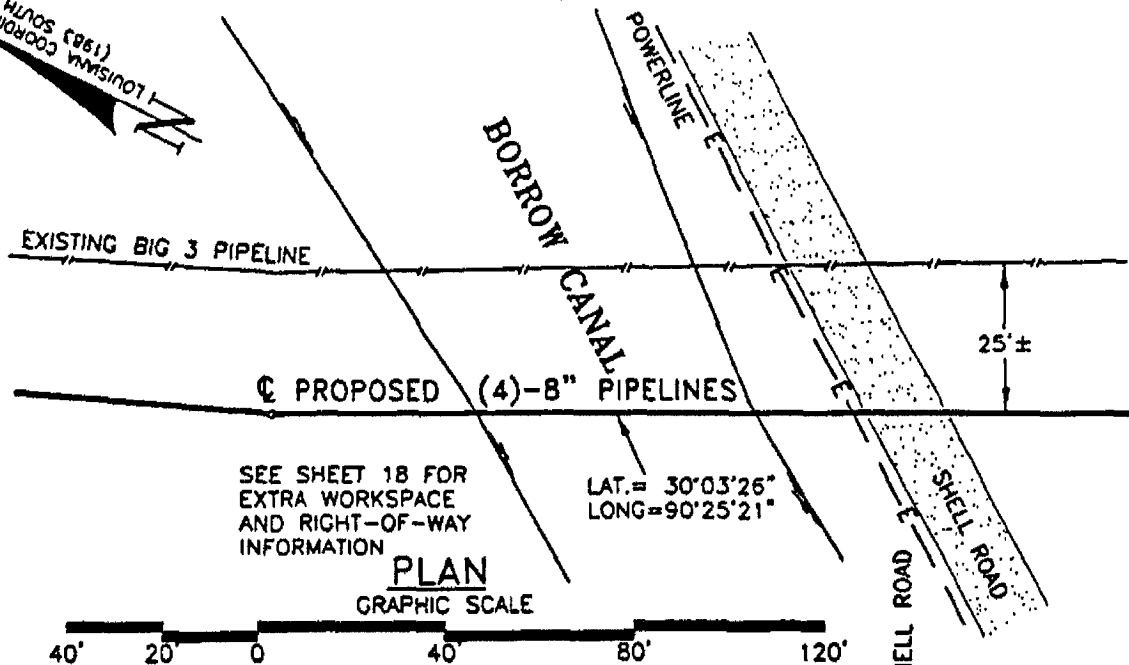

SEE SHEET 18 FOR
EXTRA WORKSPACE
AND RIGHT-OF-WAY
INFORMATION

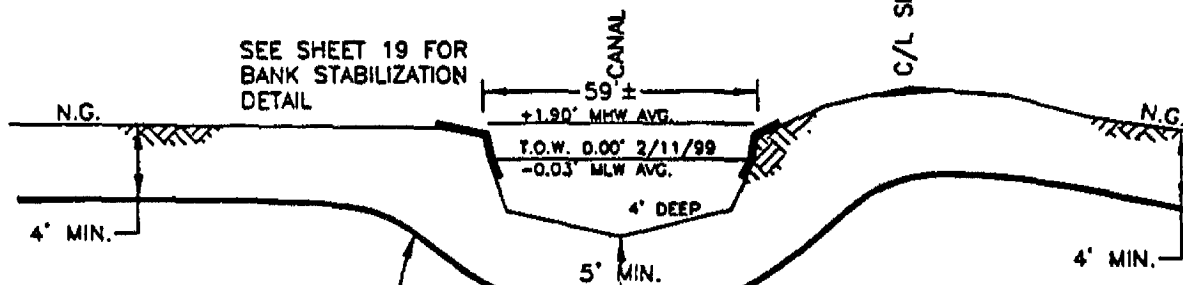

NOTE: PIPELINE TO BE INSTALLED
BY DIRECTIONAL DRILL OR
OPEN CUT METHOD.

BASED ON THE LAKE
PONTCHARTRAIN AT
FRENIER, LA. GAUGE
NO. 8555006, 8AM READING

NO.	DATE	REVISION

SORRENTO PIPELINE COMPANY, LLC

PROPOSED (4)-8" PIPELINES
FROM ENTERPRISE NORCO REFRACTORATOR TO
TRI-STATES VALVE LOCATED IN
SECTIONS 32, 42 & 43, T11S-R8E AND SECTIONS 21, 22, 25 & 26, T12S-R8E,
ST. CHARLES PARISH, LOUISIANA




14



Morris P. Hebert, Inc.
PROFESSIONAL LAND & HYDROGRAPHIC SURVEYORS
P.O. BOX 3106 • NOLAN, LOUISIANA 70361-3106 • (504) 879-2731

DRAWN BY: GWN	SHEET: 11
CHECKED BY: JMH	SCALE: SHOWN
APPROVED BY: DEC	DATE: 2-24-00
MPH CAD FILE: 6014COE0011A0	

ST. CHARLES PARISH, LOUISIANA

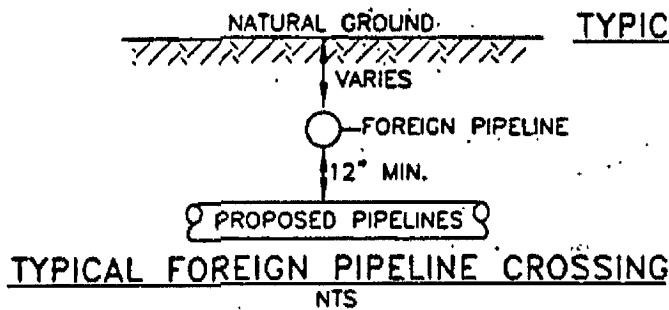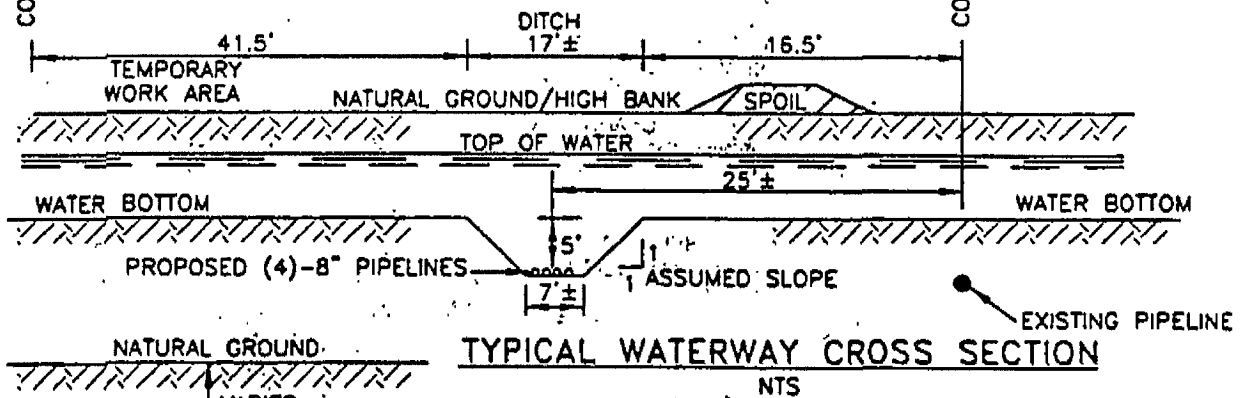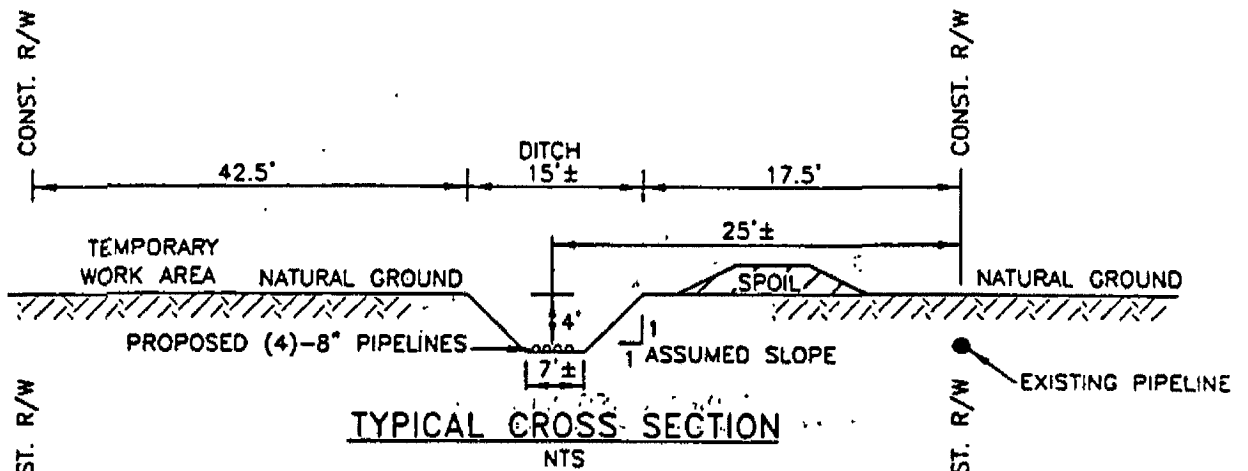

AN ON-THE-GROUND EFFORT HAS BEEN MADE TO LOCATE AND INDICATE ALL CABLES, PIPELINES, UTILITIES, ETC. CROSSED BY THE PROPOSED PIPELINE; HOWEVER, DUE TO THE INHERENT LIMITATIONS OF ELECTRONIC MAGNETIC LOCATING EQUIPMENT, MORRIS P. HEBERT, INC. IS NOT RESPONSIBLE FOR ANY NOT LOCATED DURING THE COURSE OF THE SURVEY.

NO.	DATE	REVISION

SORRENTO PIPELINE COMPANY, LLC

PROPOSED (4)-8" PIPELINES
 FROM ENTERPRISE NORCO REFRACATIONATOR TO
 TRI-STATES VALVE, LOCATED IN
 SECTIONS 32, 42 & 43, T11S-R8E AND SECTIONS 21, 22, 25 & 26, T12S-R8E,
 ST. CHARLES PARISH, LOUISIANA


MPH
 Morris P. Hebert, Inc.
 PROFESSIONAL LAND & HYDROGRAPHIC SURVEYORS
 P.O. BOX 3106 • HOUMA, LOUISIANA 70361-3106 • (504) 879-2731

DRAWN BY: GWN	SHEET: 12
CHECKED BY: JMH	SCALE: SHOWN
APPROVED BY: DEC	DATE: 2-24-00
MPH CAD FILE: 6014COE0012A0	

ST. CHARLES PARISH, LOUISIANA

SECTION 21, T12S-R8E


191513 (2012) MISSISSIPPI
 191513 (2012) LOUISIANA
 191513 (2012) COMPACT STATE

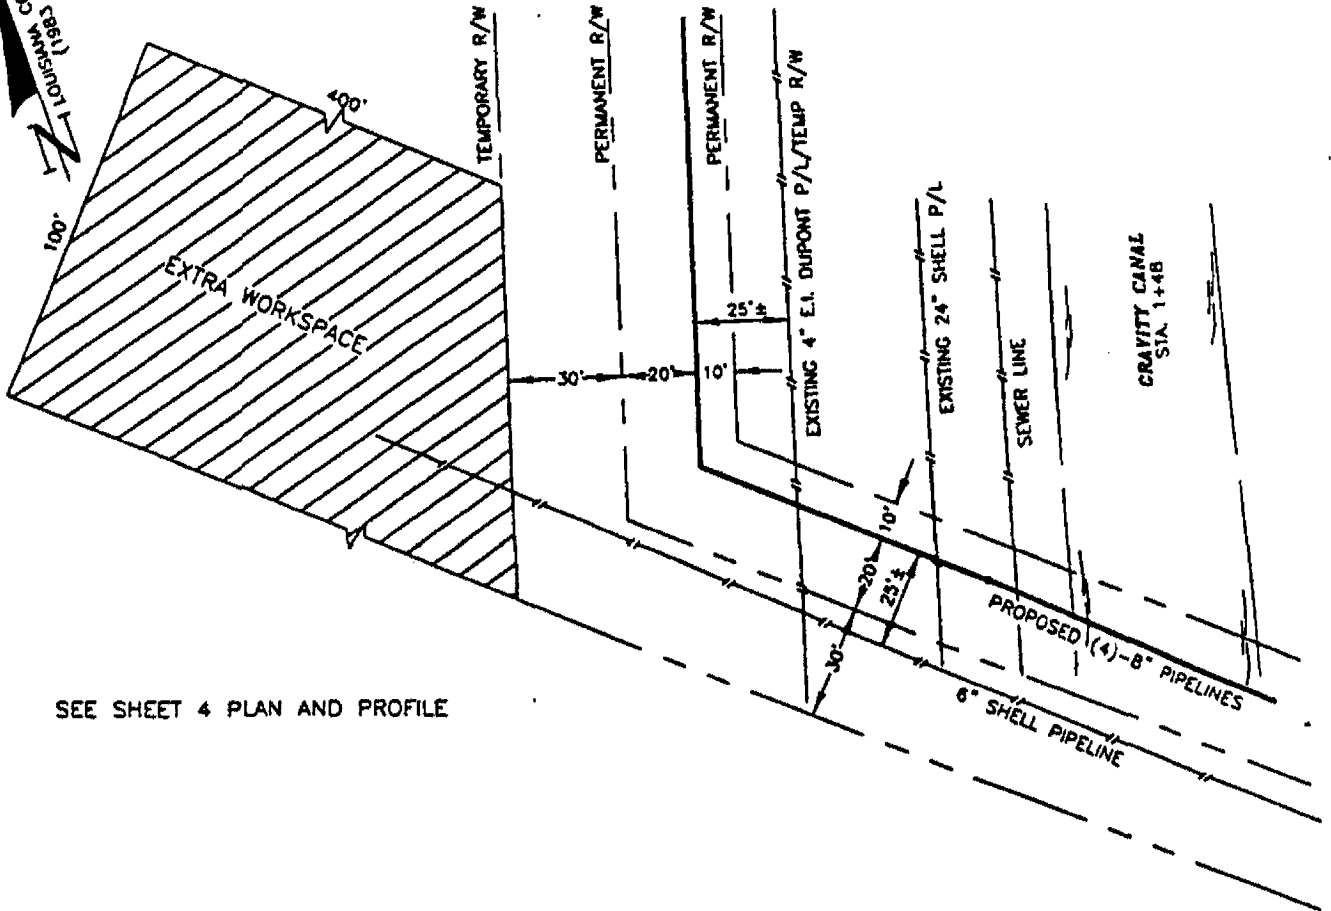

SEE SHEET 4 PLAN AND PROFILE

PLAN

 GRAPHIC SCALE



NO.	DATE	REVISION

SORRENTO PIPELINE COMPANY, LLC

PROPOSED (4)-8" PIPELINES
 FROM ENTERPRISE NORCO REFRACATIONATOR TO
 TRI-STATES VALVE LOCATED IN
 SECTIONS 32, 42 & 43, T11S-R8E AND SECTIONS 21, 22, 25 & 26, T12S-R8E,
 ST. CHARLES PARISH, LOUISIANA

16




Morris P. Hebert, Inc.
 PROFESSIONAL LAND & HYDROGRAPHIC SURVEYORS
 P.O. BOX 3106 • MOUMA, LOUISIANA 70381-3106 • (504) 879-2731

DRAWN BY: GWN	SHEET: 13
CHECKED BY: JMH	SCALE: SHOWN
APPROVED BY: DEC	DATE: 3-1-00
MPH CAD FILE: 6014COE0013A0	

ST. CHARLES PARISH, LOUISIANA

SECTION 21, T12S-R8E

LOUISIANA COORDINATE SYSTEM
(3002 H1005 0861)
1983 SOUTH ZONE

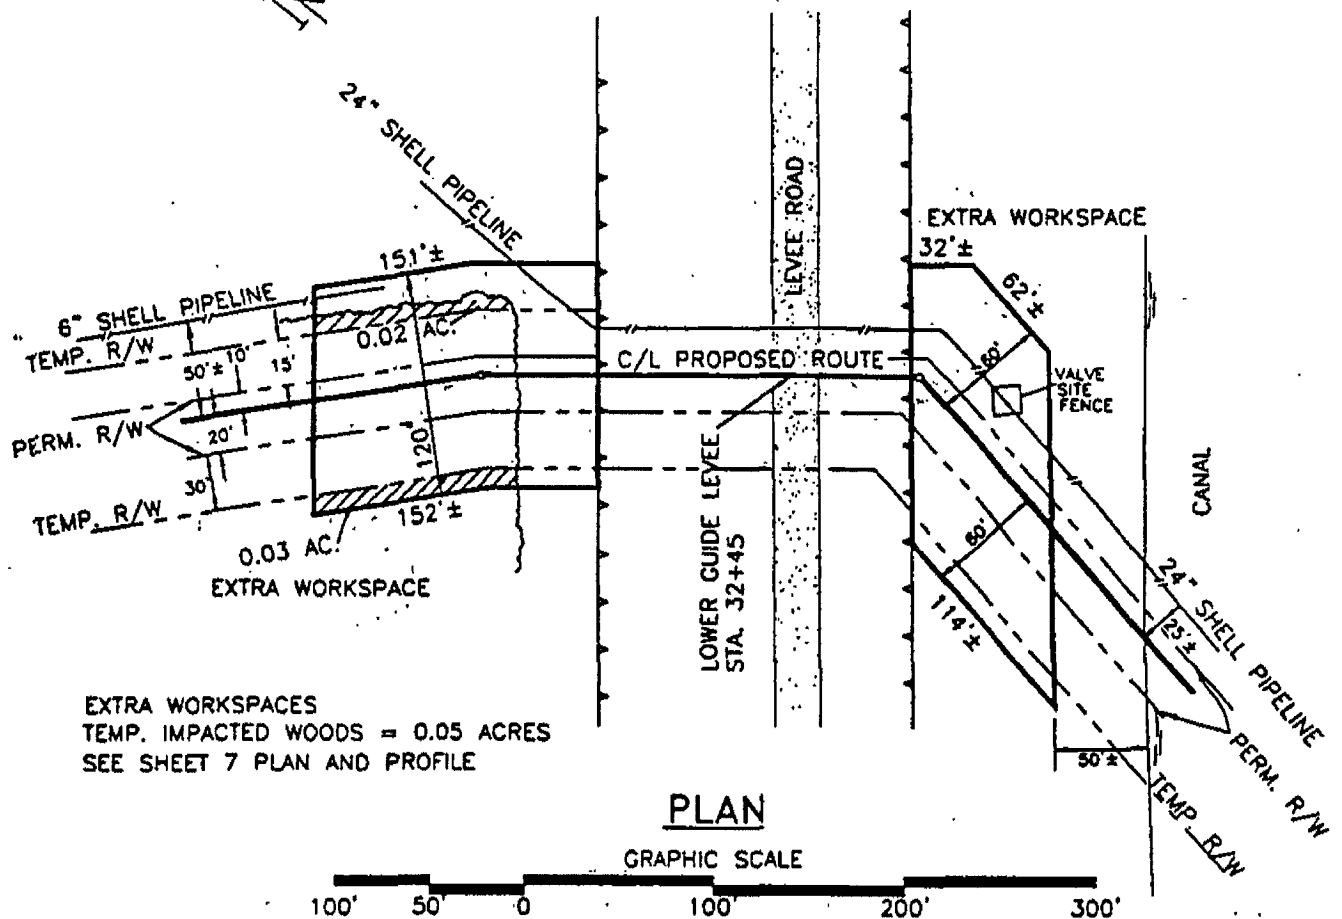

EXTRA WORKSPACES
TEMP. IMPACTED WOODS = 0.05 ACRES
SEE SHEET 7 PLAN AND PROFILE

PLAN

GRAPHIC SCALE


100' 50' 0 100' 200' 300'

NO.	DATE	REVISION
-----	------	----------

SORRENTO PIPELINE COMPANY, LLC

PROPOSED (4)-8" PIPELINES
FROM ENTERPRISE NORCO REFRACTIONATOR TO
TRI-STATES VALVE LOCATED IN
SECTIONS 32, 42 & 43, T11S-R8E AND SECTIONS 21, 22, 25 & 26, T12S-R8E,
ST. CHARLES PARISH, LOUISIANA

 11



Morris P. Hebert, Inc.
PROFESSIONAL LAND & HYDROGRAPHIC SURVEYORS
P.O. BOX 3106 • HOLMA, LOUISIANA 70361-3106 • (504) 879-2731


DRAWN BY: GWN	SHEET: 14
CHECKED BY: JMH	SCALE: SHOWN
APPROVED BY: DEC	DATE: 2-24-00
MPH CAD FILE: 6014COE0014A0	

ST. CHARLES PARISH, LOUISIANA

SECTION 21, T12S-R8E

LOUISIANA COORDINATE SYSTEM (1983 SOUTH ZONE)

STA. 42+08

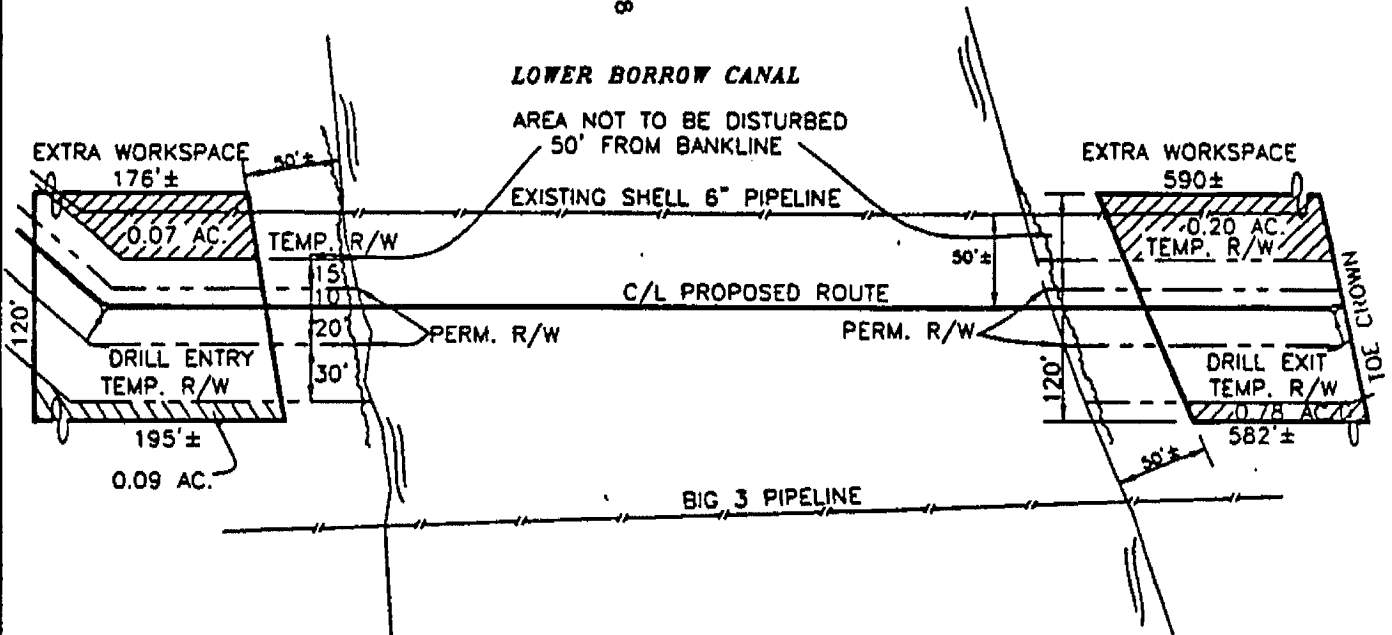

EXTRA WORKSPACES
TEMP. IMPACTED WOODS = 1.14 ACRES
SEE SHEET 8 PLAN AND PROFILE

PLAN

GRAPHIC SCALE



NO.	DATE	REVISION

SORRENTO PIPELINE COMPANY, LLC

PROPOSED (4)-8" PIPELINES
FROM ENTERPRISE NORCO REFRACATIONATOR TO
TRI-STATES VALVE LOCATED IN
SECTIONS 32, 42 & 43, T11S-R8E AND SECTIONS 21, 22, 25 & 26, T12S-R8E,
ST. CHARLES PARISH, LOUISIANA


18



Morris P. Hebert, Inc.
PROFESSIONAL LAND & HYDROGRAPHIC SURVEYORS
P.O. BOX 3106 • MOUMA, LOUISIANA 70381-3106 • (504) 879-2731

DRAWN BY: GWN	SHEET: 15
CHECKED BY: JMH	SCALE: SHOWN
APPROVED BY: DEC	DATE: 2-24-00
MPH CAD FILE: 6014COE0015A0	

ST. CHARLES PARISH, LOUISIANA
SECTION 32, T11S-R8E

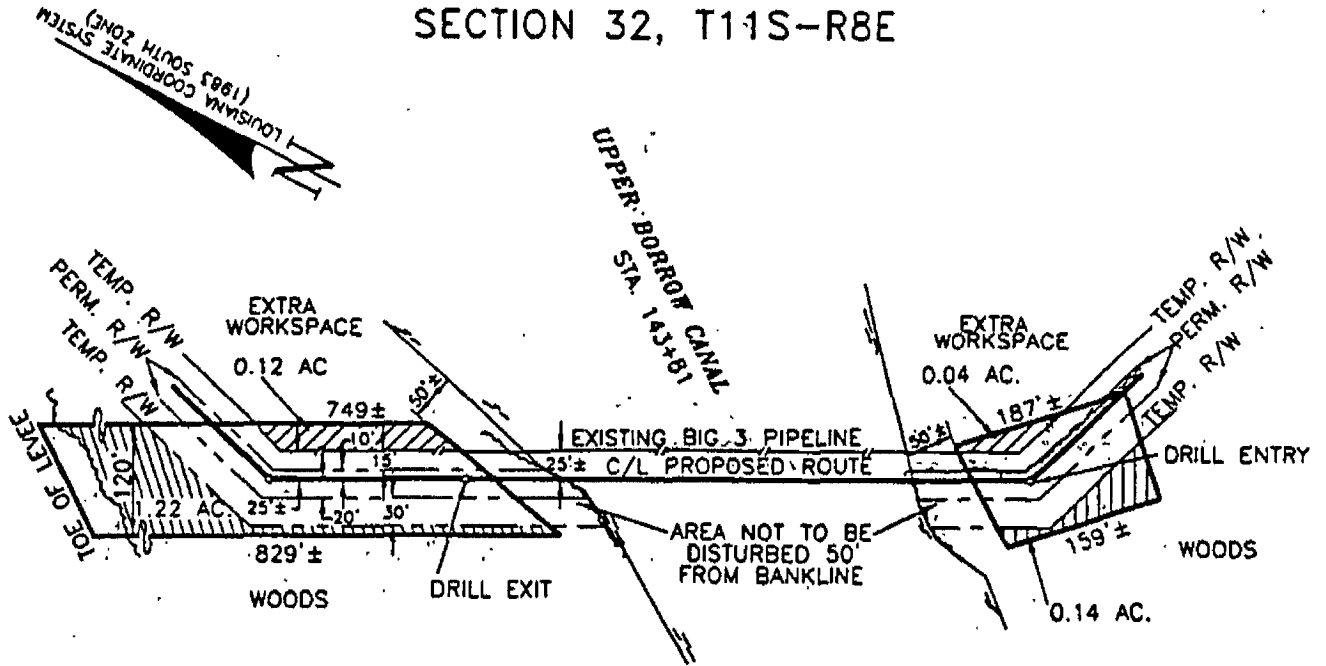

EXTRA WORKSPACES
TEMP. IMPACTED WOODS = 1.52 ACRES
SEE SHEET 9 PLAN AND PROFILE

PLAN

GRAPHIC SCALE




NO.	DATE	REVISION
-----	------	----------

SORRENTO PIPELINE COMPANY, LLC

PROPOSED (4)-8" PIPELINES
FROM ENTERPRISE NORCO REFRACTORATOR TO
TRI-STATES VALVE LOCATED IN
SECTIONS 32, 42 & 43, T11S-R8E AND SECTIONS 21, 22, 25 & 26, T12S-R8E,
ST. CHARLES PARISH, LOUISIANA

 (19)




Morris P. Hebert, Inc.
PROFESSIONAL LAND & HYDROGRAPHIC SURVEYORS
P.O. BOX 3106 • MOUMA, LOUISIANA 70381-3106 • (504) 879-2731

DRAWN BY: GWN	SHEET: 16
CHECKED BY: JMH	SCALE: SHOWN
APPROVED BY: DEC	DATE: 2-24-00
MPH CAD FILE: 6014COE0015A0	

ST. CHARLES PARISH, LOUISIANA

SECTION 32, T11S-R8E

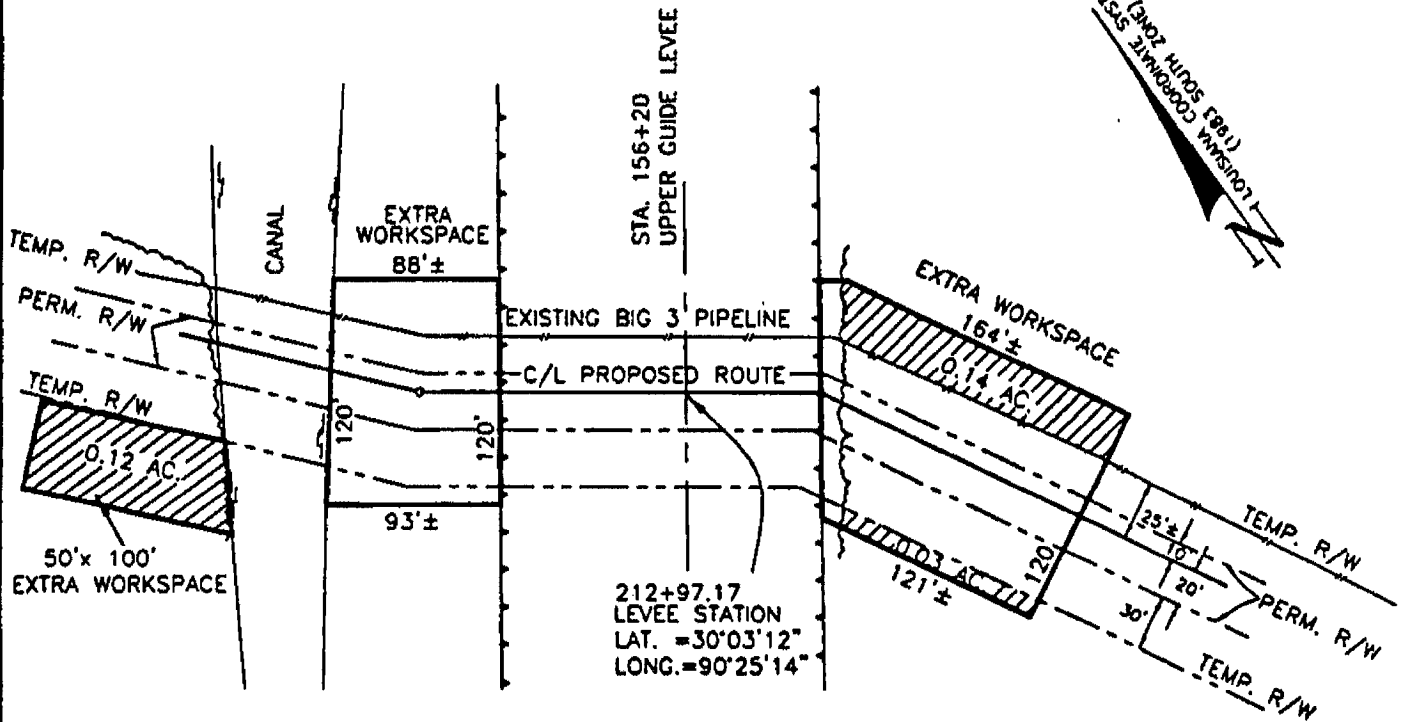

EXTRA WORKSPACES
 TEMPORARY IMPACTED WOODS = 0.29 ACRES
 SEE SHEET 10 PLAN AND PROFILE

PLAN

GRAPHIC SCALE



NO.	DATE	REVISION

SORRENTO PIPELINE COMPANY, LLC

PROPOSED (4)-8" PIPELINES
 FROM ENTERPRISE NORCO REFRACTIONATOR TO
 TRI-STATES VALVE LOCATED IN
 SECTIONS 32, 42 & 43, T11S-R8E AND SECTIONS 21, 22, 25 & 26, T12S-R8E,
 ST. CHARLES PARISH, LOUISIANA

20



Morris P. Hebert, Inc.
 PROFESSIONAL LAND & HYDROGRAPHIC SURVEYORS
 P.O. BOX 3106 • MOUMA, LOUISIANA 70361-3106 • (504) 878-2731


DRAWN BY: GWN	SHEET: 17
CHECKED BY: JMH	SCALE: SHOWN
APPROVED BY: DEC	DATE: 2-24-00
MPH CAD FILE: 6014COE0017A0	

ST. CHARLES PARISH, LOUISIANA

SECTION 42, T11S-R8E

(3NOV 2000 08:11)
LOUISIANA COORDINATE SYSTEM
SOUTH ZONE


LAT. = 30°03'26"
LONG. = 90°25'21"

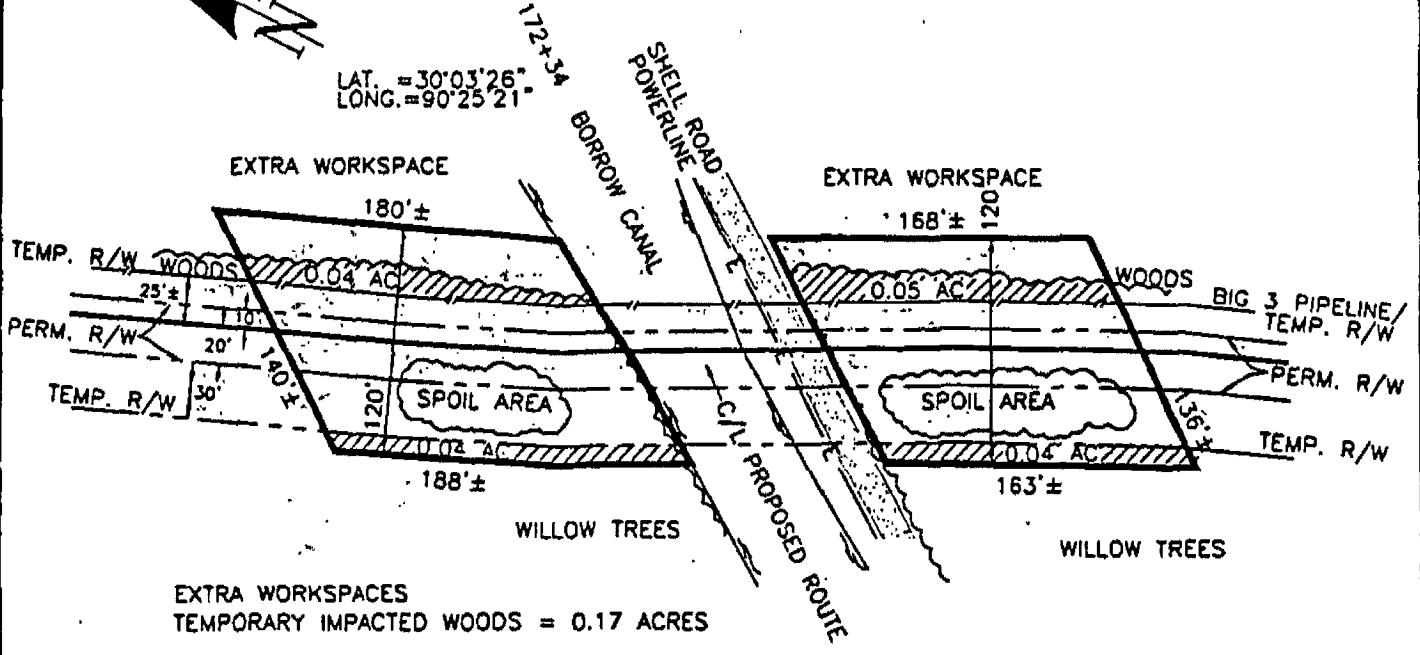

EXTRA WORKSPACES
TEMPORARY IMPACTED WOODS = 0.17 ACRES
SEE SHEET 11 PLAN AND PROFILE

PLAN

 GRAPHIC SCALE



NO.	DATE	REVISION

SORRENTO PIPELINE COMPANY, LLC


PROPOSED (4)-8" PIPELINES
FROM ENTERPRISE NORCO REFRACTIONATOR TO
TRI-STATES VALVE LOCATED IN
SECTIONS 32, 42 & 43, T11S-R8E AND SECTIONS 21, 22, 25 & 26, T12S-R8E,
ST. CHARLES PARISH, LOUISIANA

Morris P. Hebert, Inc.
PROFESSIONAL LAND & HYDROGRAPHIC SURVEYORS
P.O. BOX 3108 • MOUMA, LOUISIANA 70361-3108 • (504) 879-2731


DRAWN BY: GWN	SHEET: 18
CHECKED BY: JMH	SCALE: SHOWN
APPROVED BY: DEC.	DATE: 2-24-00
MPH CAD FILE: 6014COE0018A0	

ST. CHARLES PARISH, LOUISIANA

APPROXIMATELY 12 CUBIC YARDS (MAX.) OF MATERIAL TO BE PLACED OVER BACKFILLED PIPE DITCH TO PROVIDE STABILIZATION ALONG DISTURBED BANKLINE.

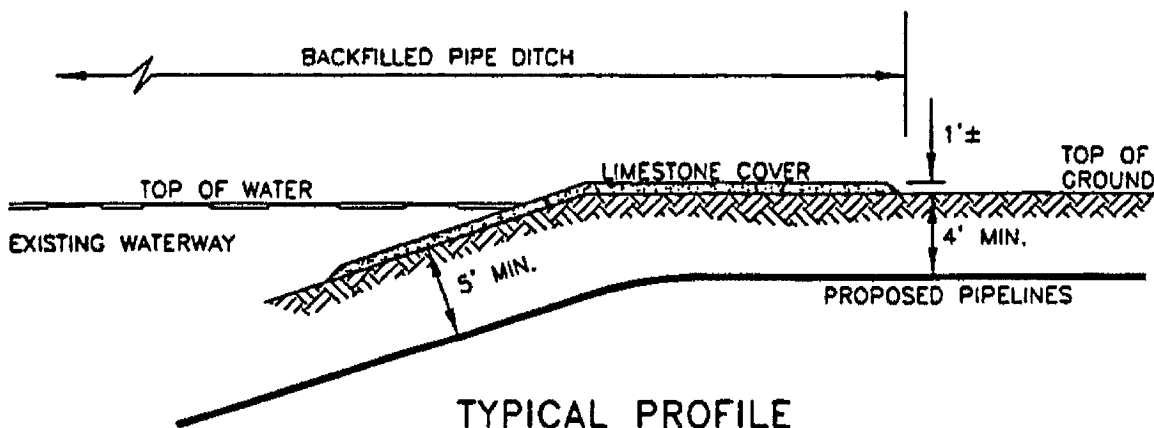

TYPICAL PROFILE

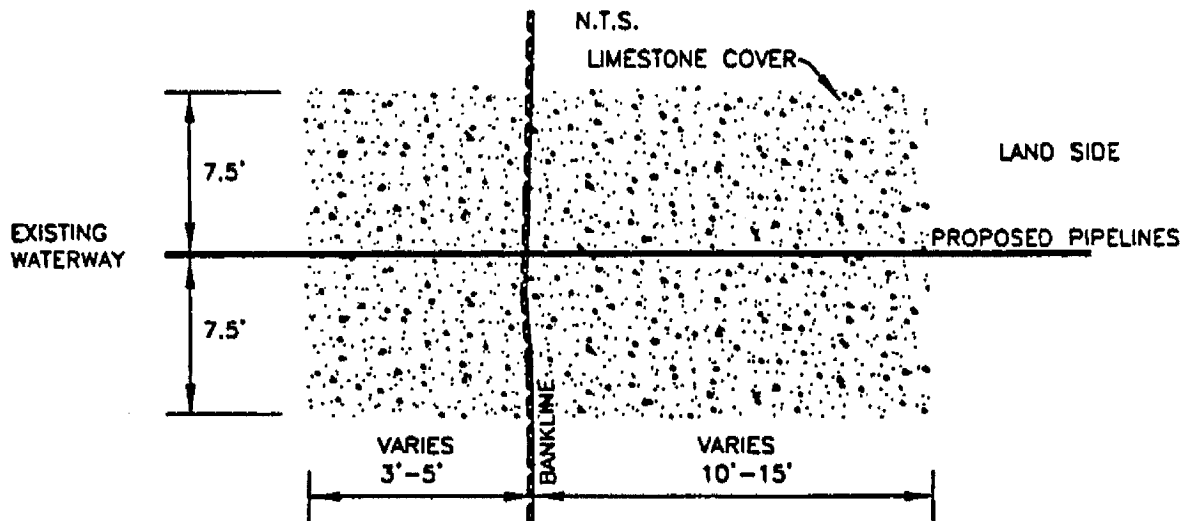

TYPICAL PLAN

N.T.S.

NO.	DATE	REVISION
-----	------	----------

SORRENTO PIPELINE COMPANY, LLC

PROPOSED (4)-8" PIPELINES
 FROM ENTERPRISE NORCO REFRACATIONATOR TO
 TRI-STATES VALVE LOCATED IN
 SECTIONS 32, 42 & 43, T11S-R8E AND SECTIONS 21, 22, 25 & 26, T12S-R8E,
 ST. CHARLES PARISH, LOUISIANA


22



Morris P. Hebert, Inc.
 PROFESSIONAL LAND & HYDROGRAPHIC SURVEYORS
 P.O. BOX 3106 • NOLAN, LOUISIANA 70361-3106 • (504) 879-2731

DRAWN BY: GWN	SHEET: 19
CHECKED BY: JMH	SCALE: SHOWN
APPROVED BY: DEC	DATE: 2-24-00
MPH CAD FILE: 6014COE0019A0	

ST. CHARLES PARISH, LOUISIANA

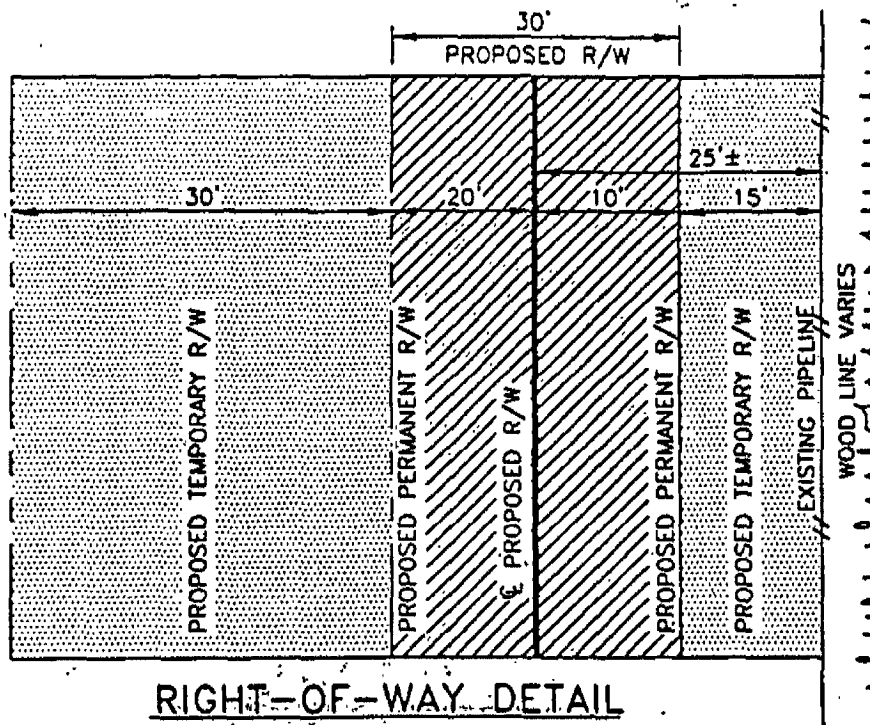

RIGHT-OF-WAY DETAIL

NO WOODS IMPACTED BY R/W

- 0+00 TO 33+58.66
- 39+88.73 TO 43+62.30
- 47+01.53 TO 56+64.65
- 68+73.88 TO 76+56.79
- 79+93.12 TO 102+85.53
- 141+77.02 TO 145+47.22
- 155+34.60 TO 158+79.04
- 171+63.95 TO 172+74.14
- 175+76.04 TO 176+89.24

WOODS IMPACTED BY R/W

- 33+58.66 TO 39+88.73
- 43+62.30 TO 47+01.53
- 56+64.65 TO 68+73.88
- 76+56.79 TO 79+93.12
- 102+85.53 TO 141+77.02
- 145+47.22 TO 155+34.60
- 158+79.04 TO 171+63.95
- 172+74.14 TO 175+76.04

WOODS IMPACTED BY R/W


- PERMANENT = 5.33± ACRES
- TEMPORARY = 6.86± ACRES
- EXTRA WORK SPACE = 3.17± ACRES

NO.	DATE	REVISION

SORRENTO PIPELINE COMPANY, LLC

PROPOSED (4)-8" PIPELINES
 FROM ENTERPRISE NORCO REFRACATIONATOR TO
 TRI-STATES VALVE LOCATED IN
 SECTIONS 32, 42 & 43, T11S-R8E AND SECTIONS 21, 22, 25 & 26, T12S-R8E,
 ST. CHARLES PARISH, LOUISIANA

 53



Morris P. Hebert, Inc.
 PROFESSIONAL LAND & HYDROGRAPHIC SURVEYORS
 P.O. BOX 3106 • NOLLA, LOUISIANA 70361-3106 • (504) 879-2731

DRAWN BY: GWN	SHEET: 20
CHECKED BY: JMH	SCALE: SHOWN
APPROVED BY: DEC	DATE: 2-24-00
MPH CAD FILE: 6014COE0020AO	

NOTES:

1. AS-BUILT DRAWINGS SHALL BE SUBMITTED WITHIN 90 DAYS OF COMPLETION OF THIS PROJECT TO THE LOUISIANA DEPARTMENT OF NATURAL RESOURCES, OFFICE OF CONSERVATION, PIPELINE DIVISION, P.O. BOX 44487, BATON ROUGE, LA. 70804-4487 AND TO THE LOUISIANA DEPARTMENT OF NATURAL RESOURCES, COASTAL MANAGEMENT DIVISION, P.O. BOX 44487, BATON ROUGE, LA. 70804-4487.
2. IN ORDER TO ENSURE THE SAFETY OF ALL PARTIES, THE PERMITTEE SHALL CONTACT THE LOUISIANA ONE CALL SYSTEM (1-800-272-3020) A MINIMUM OF 48 HOURS PRIOR TO THE COMMENCEMENT OF ANY EXCAVATION (DIGGING, DREDGING, JETTING, ETC.) OR DEMOLITION ACTIVITY.
3. APPROXIMATELY 32,500± CUBIC YARDS OF SPOIL MATERIAL WILL BE EXCAVATED BY BACK HOE. SPOIL WILL BE PLACED ADJACENT TO PIPE DITCH DURING CONSTRUCTION. FOLLOWING CONSTRUCTION, SPOIL WILL BE RETURNED TO DITCH. APPROXIMATELY 1,900± CUBIC YARDS FILL MATERIAL WILL BE REQUIRED FOR LEVEE CROSSING.
4. APPROXIMATELY 720± CUBIC YARDS OF SPOIL MATERIAL WILL BE EXCAVATED FROM WATER BOTTOM. SPOIL WILL BE PLACED ADJACENT TO BANK LINE DURING CONSTRUCTION. FOLLOWING CONSTRUCTION, SPOIL WILL BE RETURNED TO DITCH.
5. APPROXIMATELY 72± CUBIC YARDS OF LIMESTONE WILL BE HAULED IN FOR CONSTRUCTION OF BANK STABILIZATION.
6. APPROXIMATELY 15.36± ACRES OF WOODLAND TO BE AFFECTED BY RIGHT-OF-WAY DURING CONSTRUCTION OF PROPOSED PIPELINE, 5.33± ACRES WILL BE PERMANENTLY IMPACTED, 6.86± ACRES WILL BE TEMPORARILY IMPACTED AND 3.17± ACRES WILL BE TEMPORARILY IMPACTED BY EXTRA WORKSPACE.
7. IMPACTED TREES TO BE CHIPPED AND/OR REMOVED FROM PROJECT SITE.

NO.	DATE	REVISION
-----	------	----------

SORRENTO PIPELINE COMPANY, LLC

PROPOSED (4)-8" PIPELINES
 FROM ENTERPRISE NORCO REFRACTIONATOR TO
 TRI-STATES VALVE LOCATED IN
 SECTIONS 32, 42 & 43, T11S-R8E AND SECTIONS 21, 22, 25 & 26, T12S-R8E,
 ST. CHARLES PARISH, LOUISIANA

24



Morris P. Hebert, Inc.
 PROFESSIONAL LAND & HYDROGRAPHIC SURVEYORS
 P.O. BOX 3108 • HOUMA, LOUISIANA 70361-3108 • (504) 879-2731

DRAWN BY: GWN	SHEET: 21
CHECKED BY: JMH	SCALE: SHOWN
APPROVED BY: DEC	DATE: 2-24-00
MPH CAD FILE: 6014COE0021A0	