


C:\WORK\ACTIVE\10221801.10 St. Charles Parish Government - Dunleith Pump Station\CURRENT\SITE PLAN - PRELIM\OPTION 2.dwg, OPTION 2

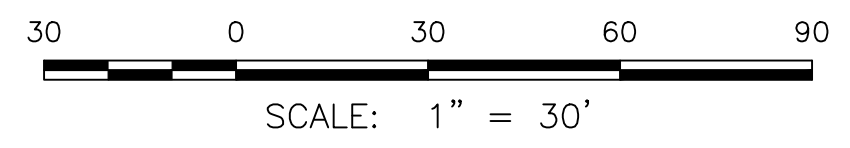

SCALE(S) SHOWN ARE BASED ON 22x34 FULL SIZE SHEET



REVISIONS:	
DATE:	REMARKS:

STAMP:  
**PRELIMINARY**  
 THIS DOCUMENT IS NOT TO BE USED FOR CONSTRUCTION BIDDING, RECORDATION, CONVEYANCE, SALES OR AS THE BASIS FOR THE ISSUANCE OF PERMIT.  
 JOSEPH C. PICCIOLA, II, P.E., P.L.S.  
 LA. LIC. NO. 25614  
 CIVIL ENGINEER

**PICCIOLA & ASSOCIATES, INC.**  
 CIVIL ENGINEERS LAND SURVEYORS NAVAL ARCHITECTS MARINE ENGINEERS  
 P.O. BOX 687  
 CUT OFF, LOUISIANA 70345  
 (985) 632-5786

DESIGNED BY: J.C.P. DRAWN BY: S.M.Z. CHECKED BY: E.R.P.

DATE:  
 JANUARY 25, 2019

SCALE:  
 1" = 30'-0"

**ST. CHARLES PARISH GOVERNMENT**  
 DUNLEITH PUMP STATION IMPROVEMENTS  
 PROPOSED SITE PLAN - OPTION "2"  
 DESTREHAN, LA LAFOURCHE PARISH

SHEET NO.  
 6 OF 7