


WEST OAKLAND DR.

EAST OAKLAND DR.

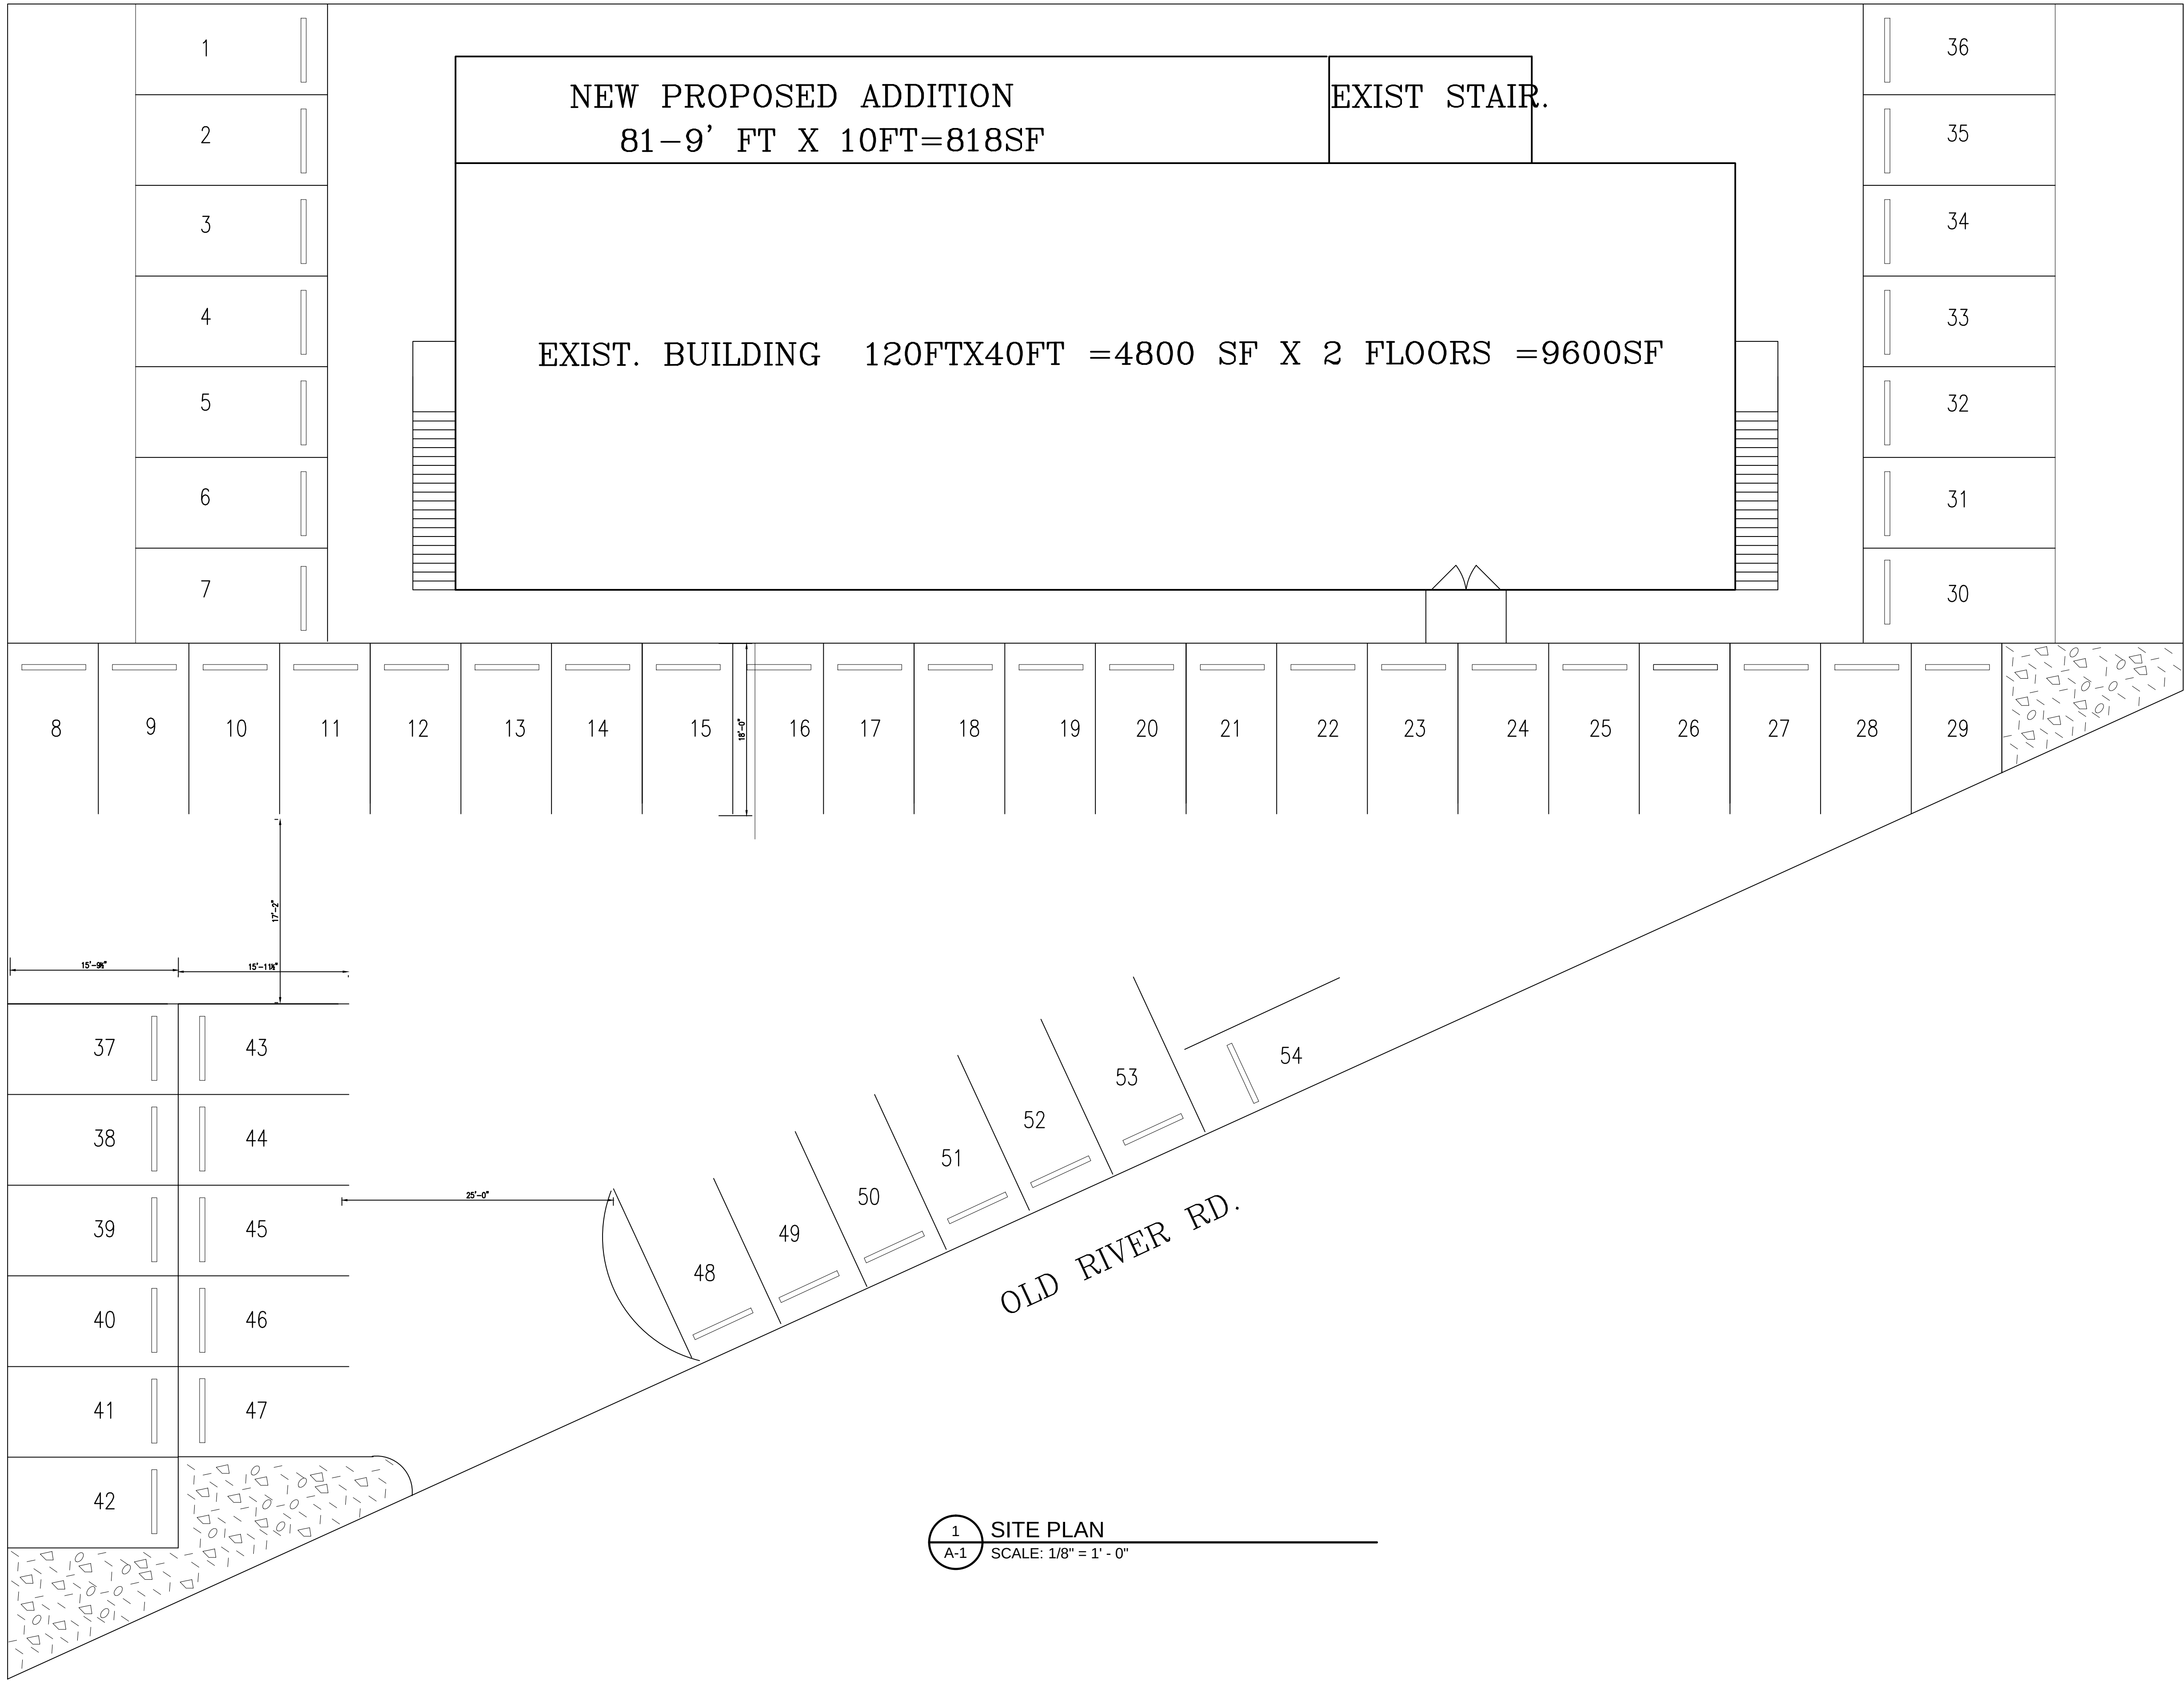

1 SITE PLAN
A-1 SCALE: 1/8" = 1' - 0"

DESIGN DEVELOPMENT
NOT FOR CONSTRUCTION

BAPS SWAMINARYAN
SANSTHA OF NEW ORLEANS
10328 RIVER ROAD
SAINT ROSE, LOUISIANA

M-K ENGINEERING, INC.
CONSULTING ENGINEERS
HVAC-PLUMBING-FIRE PROTECTION-ELECTRICAL
4323 DIVISION STREET, SUITE 211
METairie, LA 70002
TEL:(504) 887-2376, FAX:(504) 887-2302
E-MAIL: MKANSAGRAM-K-E.COM
M-K PROJECT No.: 16-069

Date: 5/03/16
Revisions:

Sheet No.

A-1