


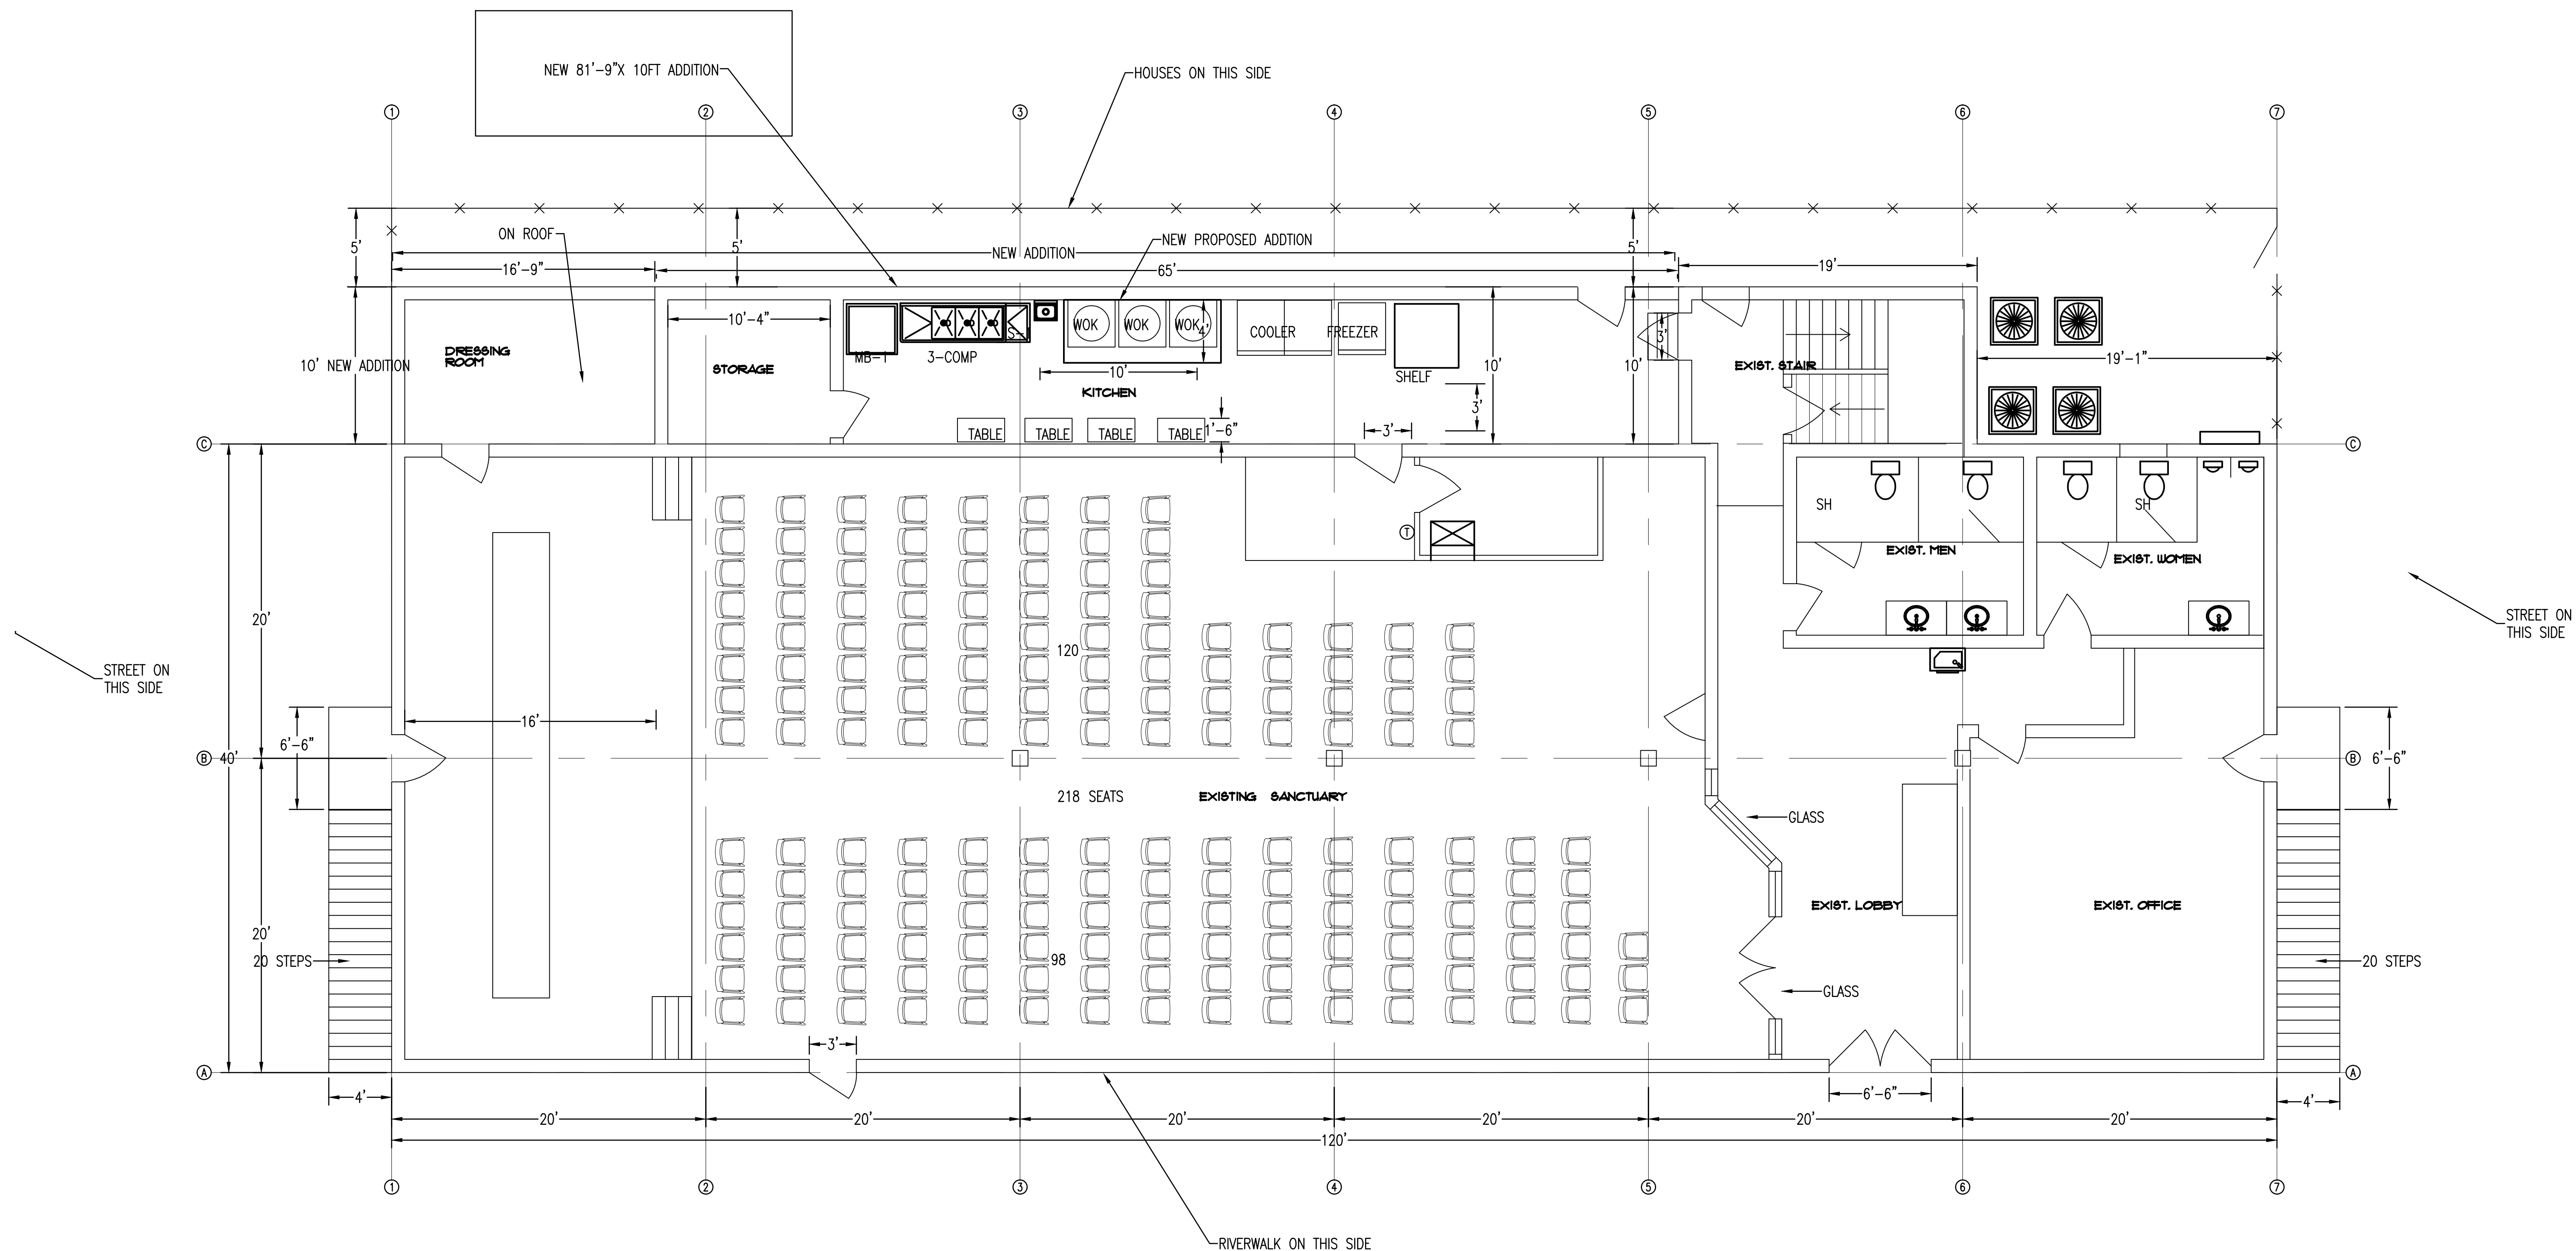

1 FLOOR PLAN
A-3 SCALE: 3/16" = 1' - 0"

DESIGN DEVELOPMENT
NOT FOR CONSTRUCTION

M-K ENGINEERING, INC.
CONSULTING ENGINEERS
HVAC-PLUMBING-FIRE PROTECTION-ELECTRICAL
4323 DIVISION STREET, SUITE 211
METairie, LA 70002
TEL: (504) 887-2376, FAX: (504) 887-2302
E-MAIL: MKSAGRAM@M-K-ENG.COM
M-K PROJECT No.: 16-069

BAPS SWAMINARYAN
SANSTHA OF NEW ORLEANS
10328 RIVER ROAD
SAINT ROSE, LOUISIANA

Date: 5/03/16
Revisions:

Sheet No.

A-2