


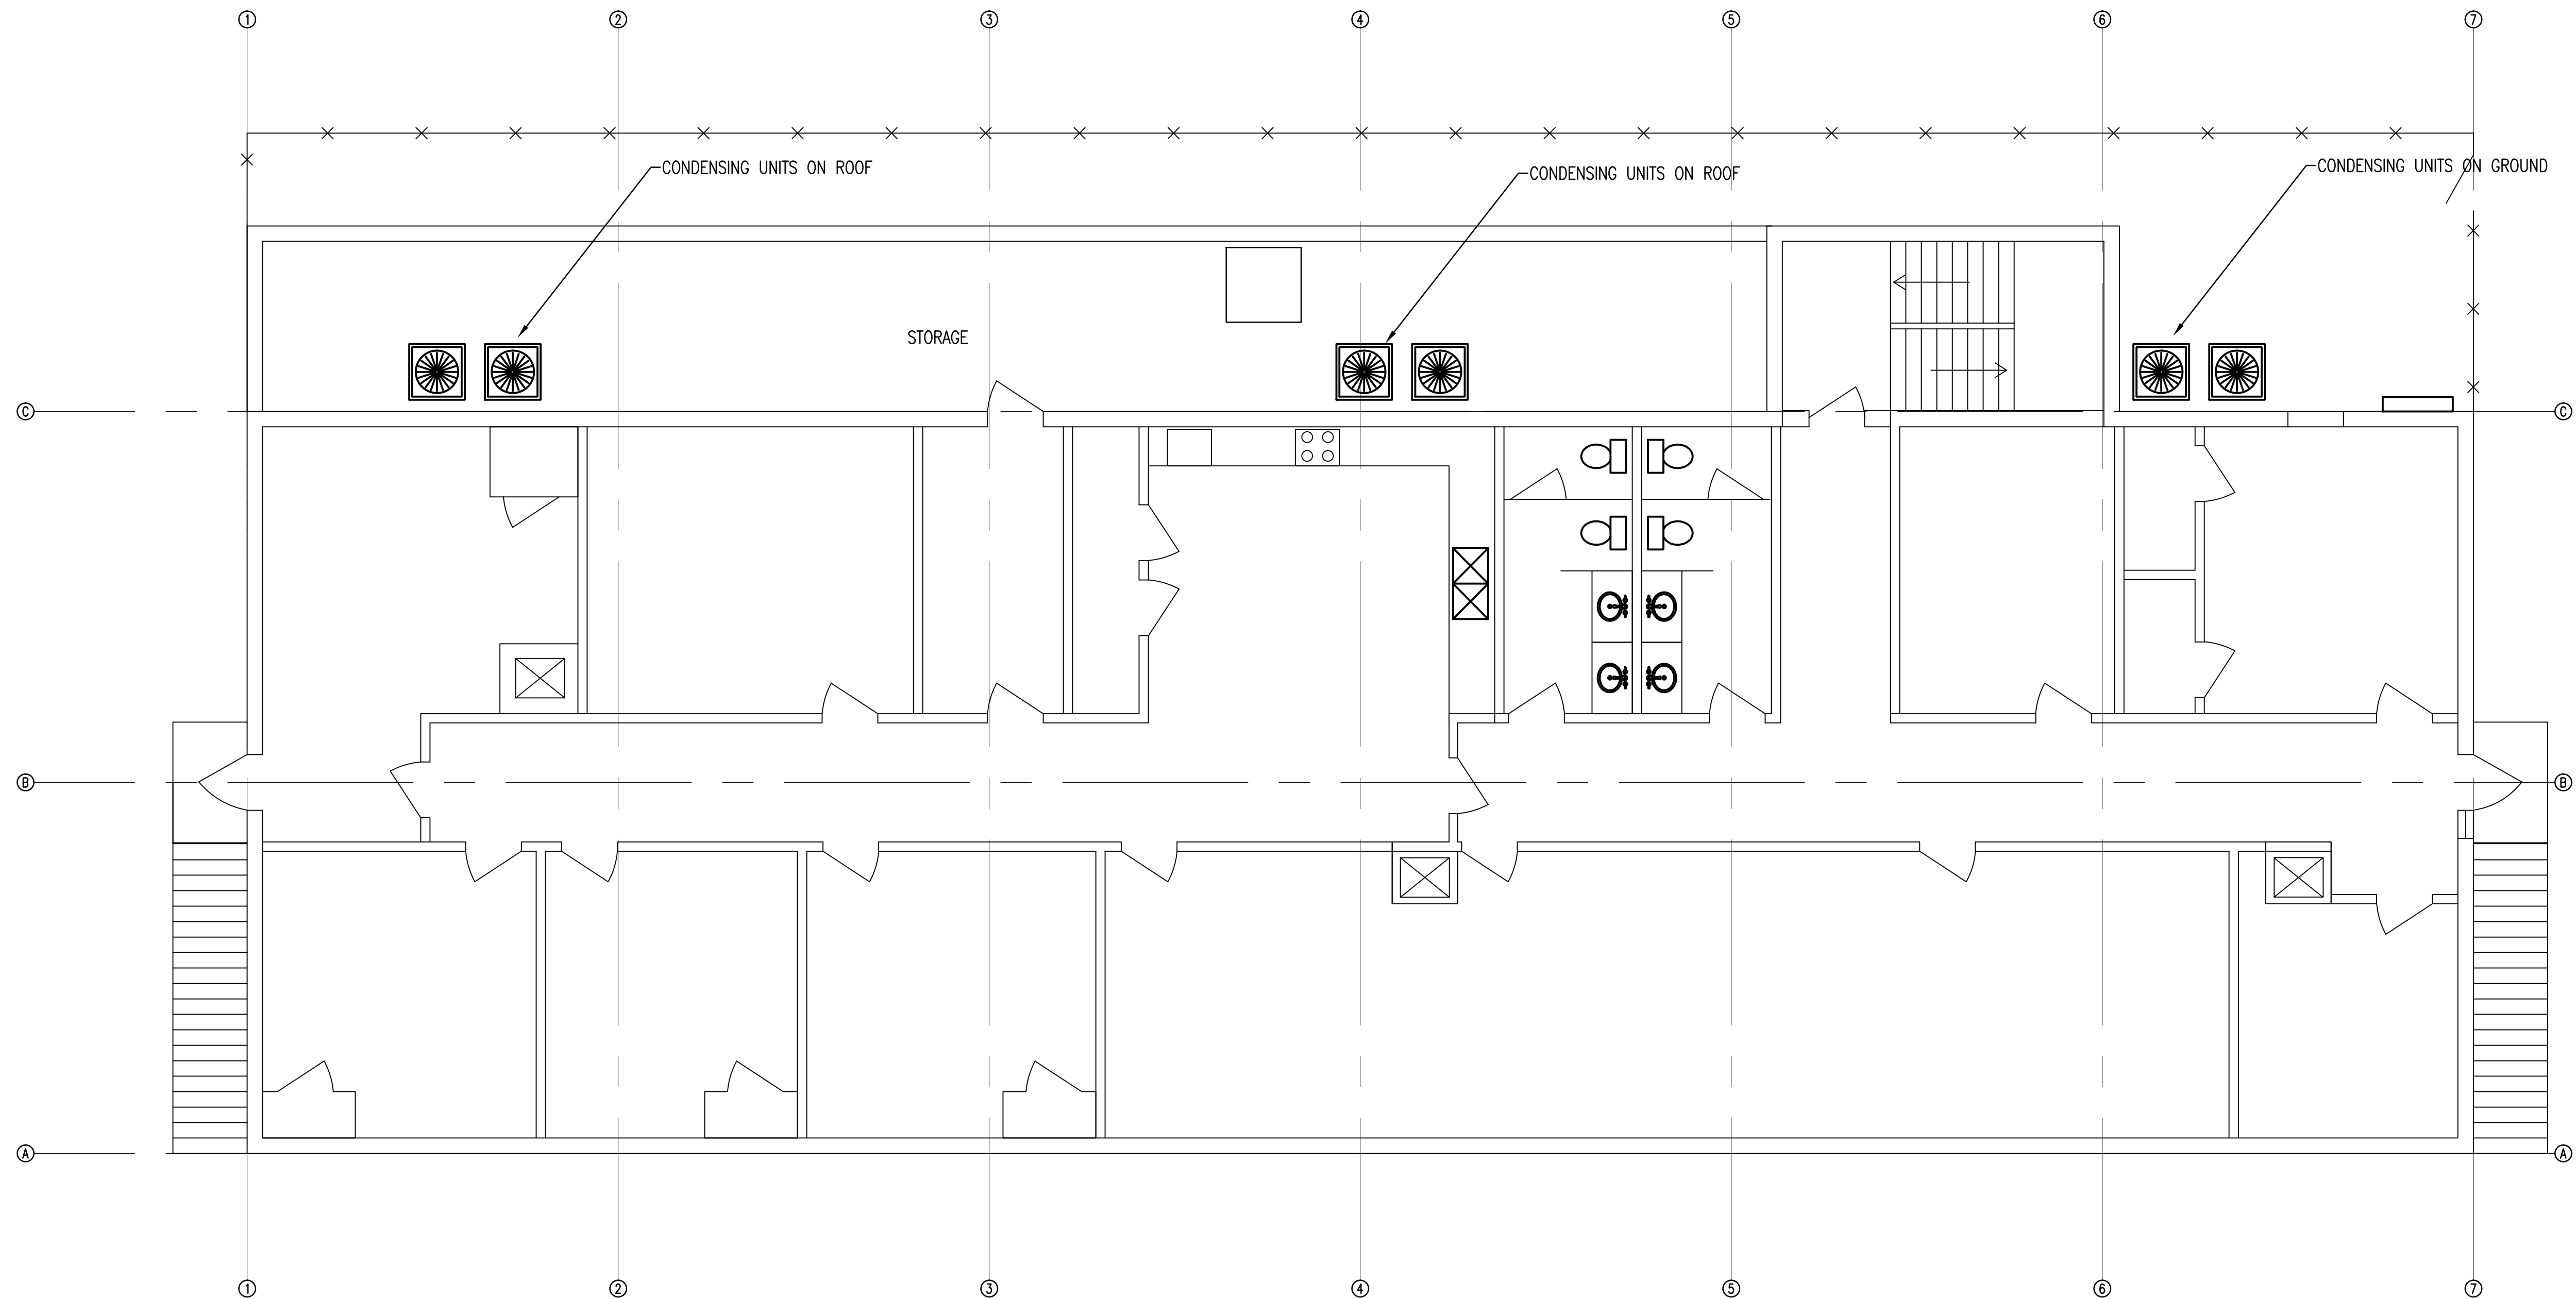

1 FLOOR PLAN
A-3 SCALE: 3/16" = 1' - 0"

DESIGN DEVELOPMENT
NOT FOR CONSTRUCTION

BAPS SWAMINARYAN
SANTHA OF NEW ORLEANS
10328 RIVER ROAD
SAINT ROSE, LOUISIANA

Date: 5/03/16
Revisions:

Sheet No.

A-3

M-K ENGINEERING, INC.
CONSULTING ENGINEERS
HVAC-PLUMBING-FIRE PROTECTION-ELECTRICAL
4323 DIVISION STREET, SUITE 211
METairie, LA 70002
TEL:(504) 887-2376, FAX:(504) 887-2302
E-MAIL: MKSAGRAM-K-E.COM
M-K PROJECT No.: 16-069